



NOTES

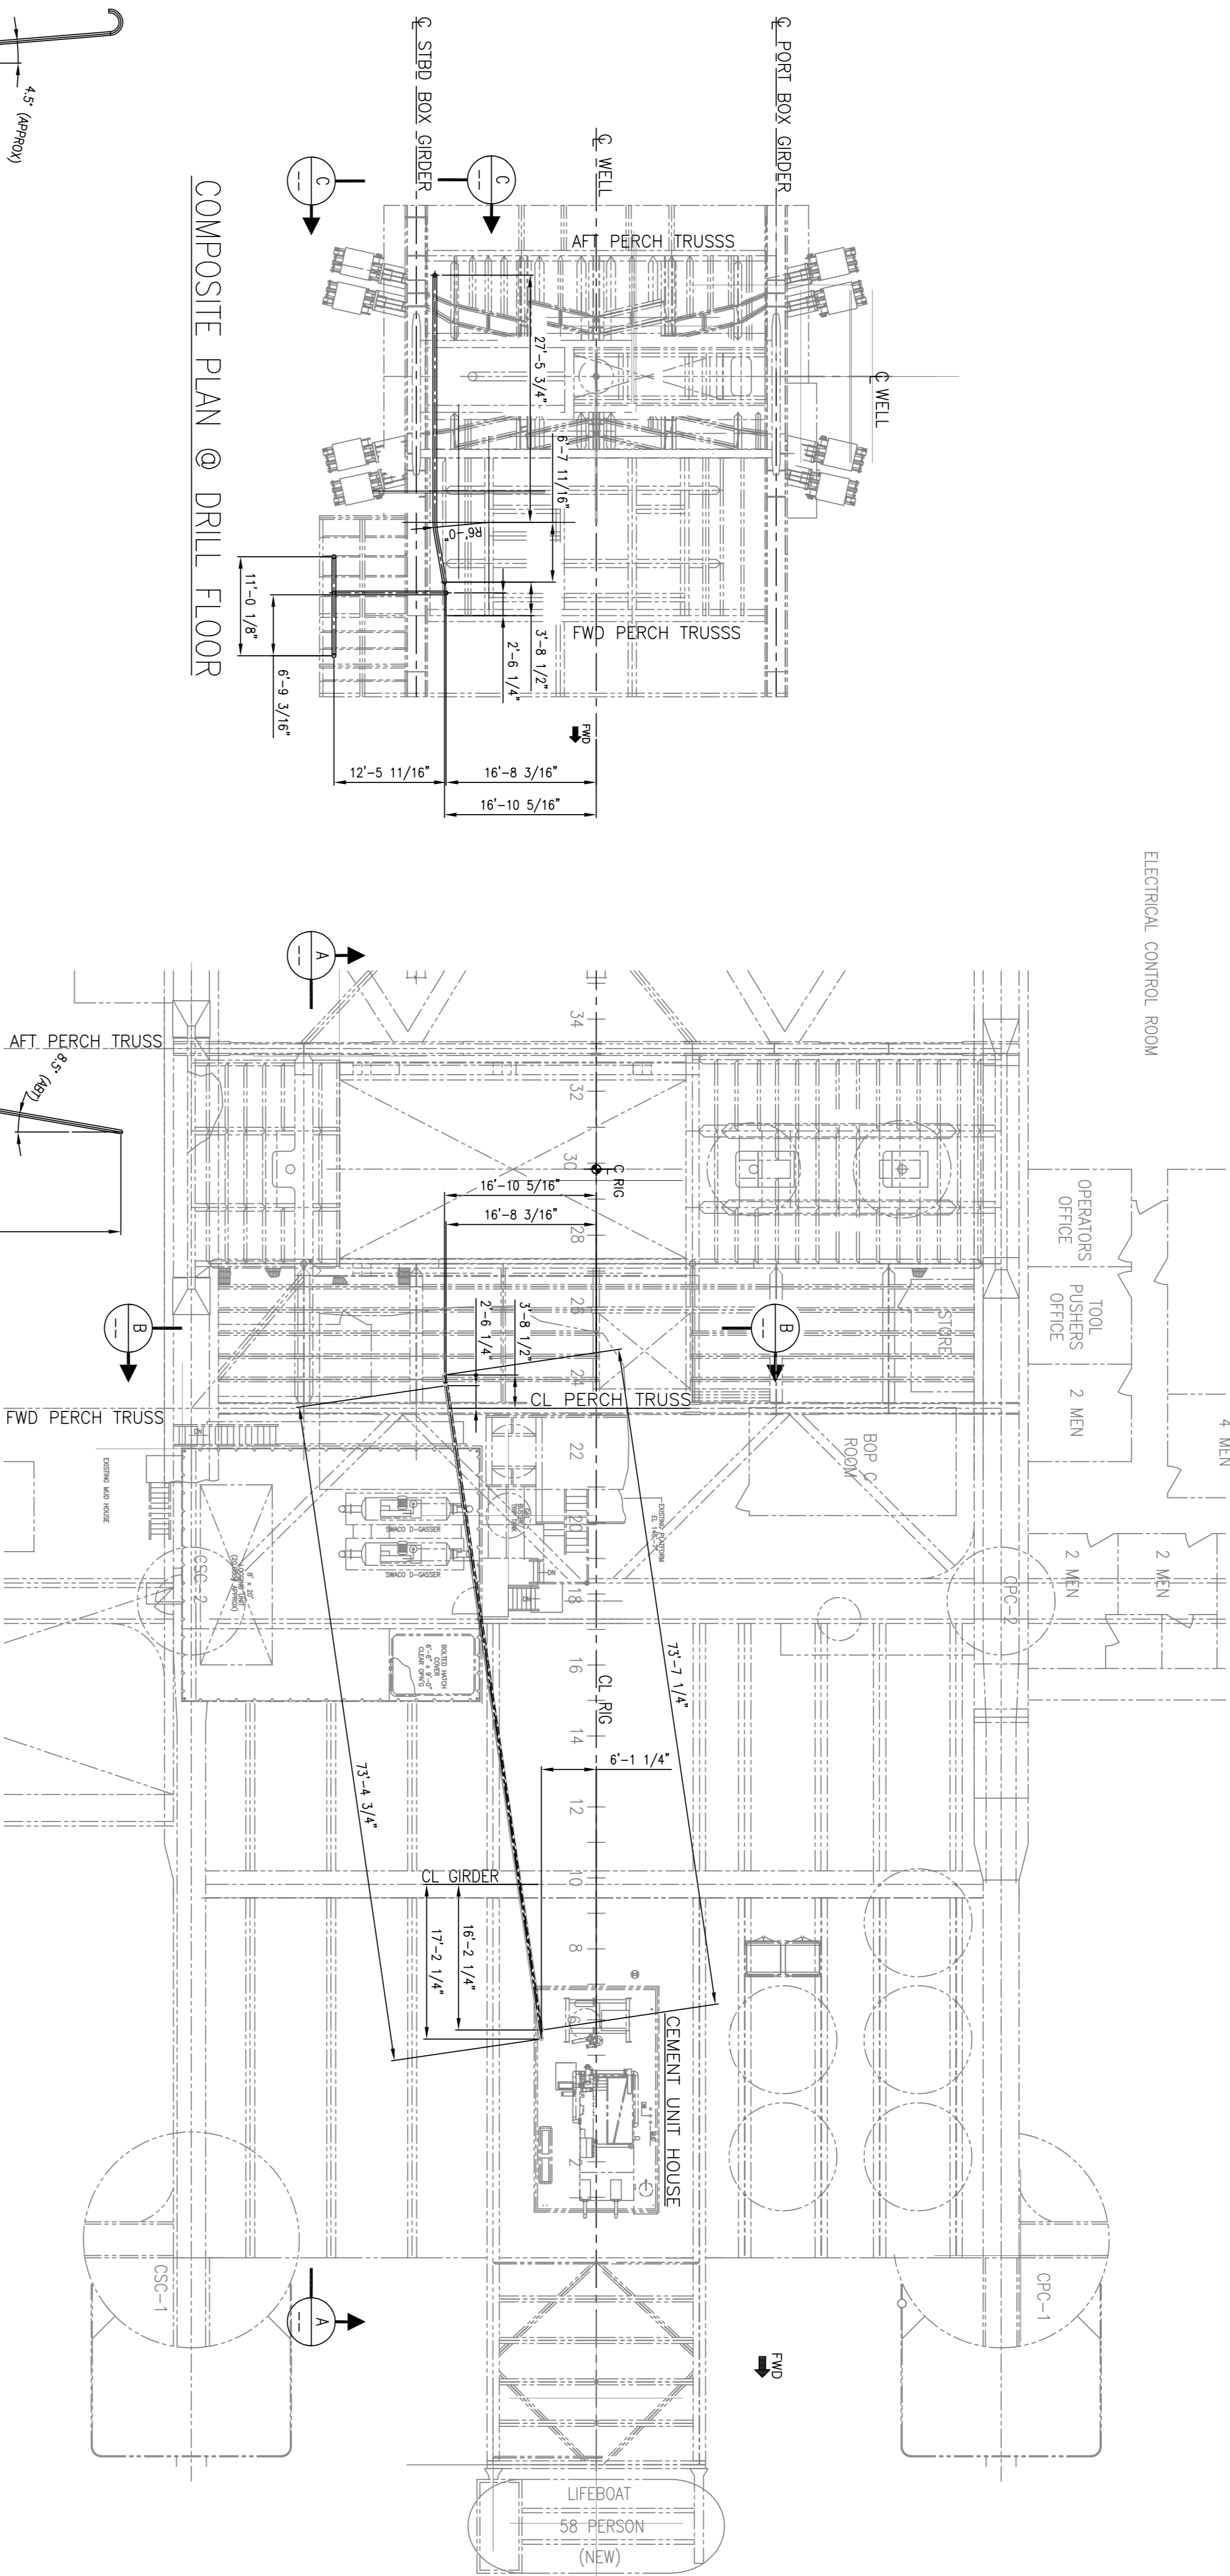

COMPOSITE PLAN @ DRILL FLOOR

COMPOSITE PLAN-HIGH PRESSURE CEMENT PIPING

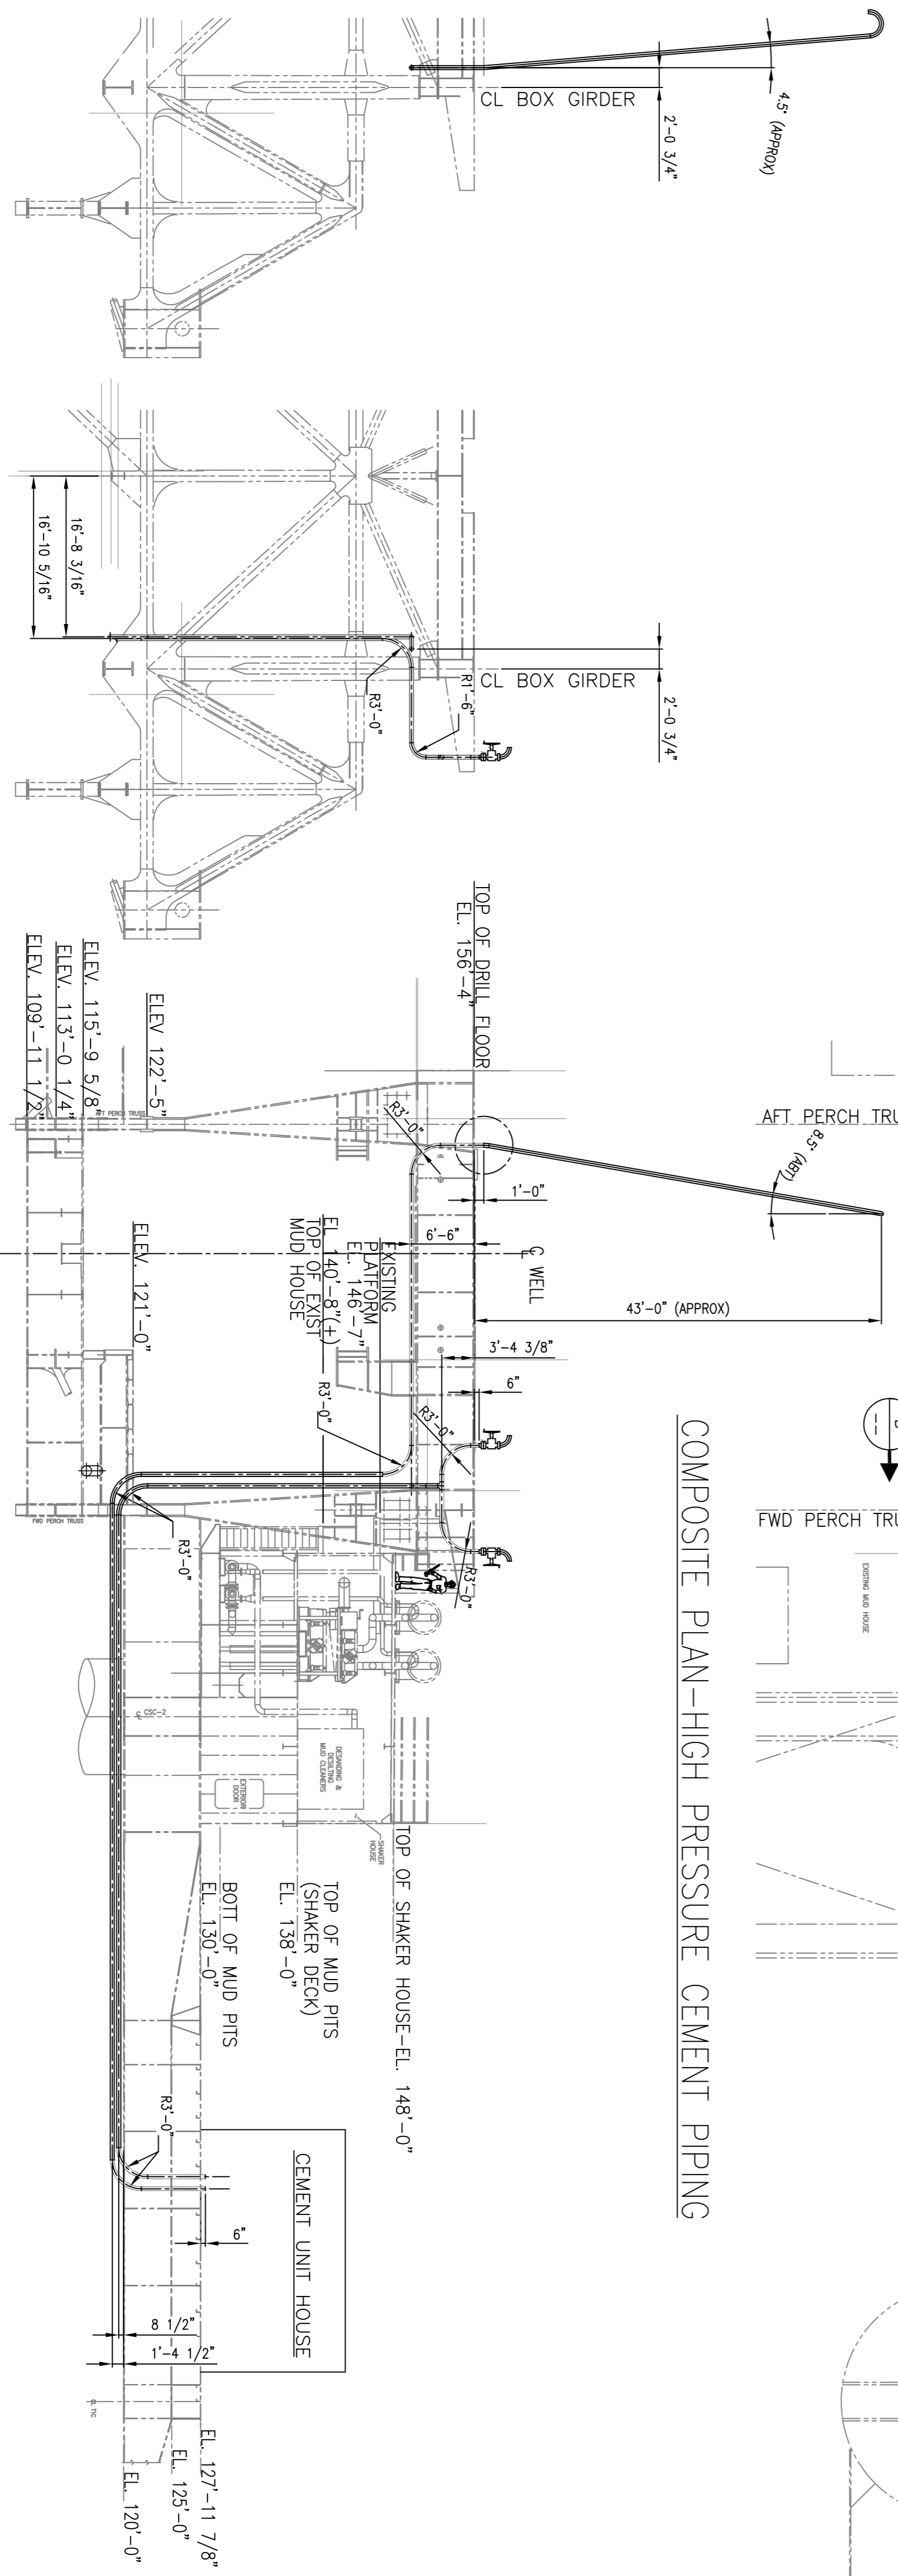


SECTION C
SCALE: 3/32"=1'-0"

SECTION B
SCALE: 3/32"=1'-0"

SECTION A
SCALE: 3/32"=1'-0"

REV	REV	REV	REV	REV	REV	REV	REV	REV	REV
1	2	3	4	5	6	7	8	9	10
STATUS	REV	REV	REV	REV	REV	REV	REV	REV	REV
1	2	3	4	5	6	7	8	9	10

Rev	Date	By	Description	OWNER ASST	USCO APPROVALS

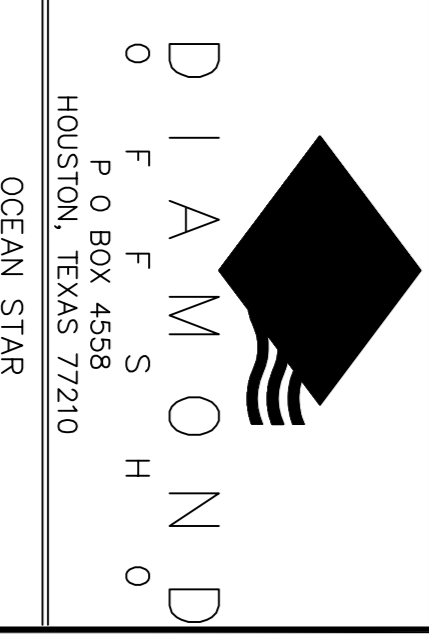

DIAMOND OFFSHORE
P O BOX 4558
HOUSTON, TEXAS 77210
OCEAN STAR

HIGH PRESSURE CEMENT PIPING ARRANGEMENT

ENG: PK/PA CHKD: DWG No.:
DRAWN: MWM APPROD: 167-PD-014
SCALE: 3/32"=1'-0" ACAD NAME: 167PD14A.DWG REV # 0
DATE: 9/24/96 SHIT 1 OF 2