


I-320-01 NOTE 7
DRAINAGE SEPARATION TANK

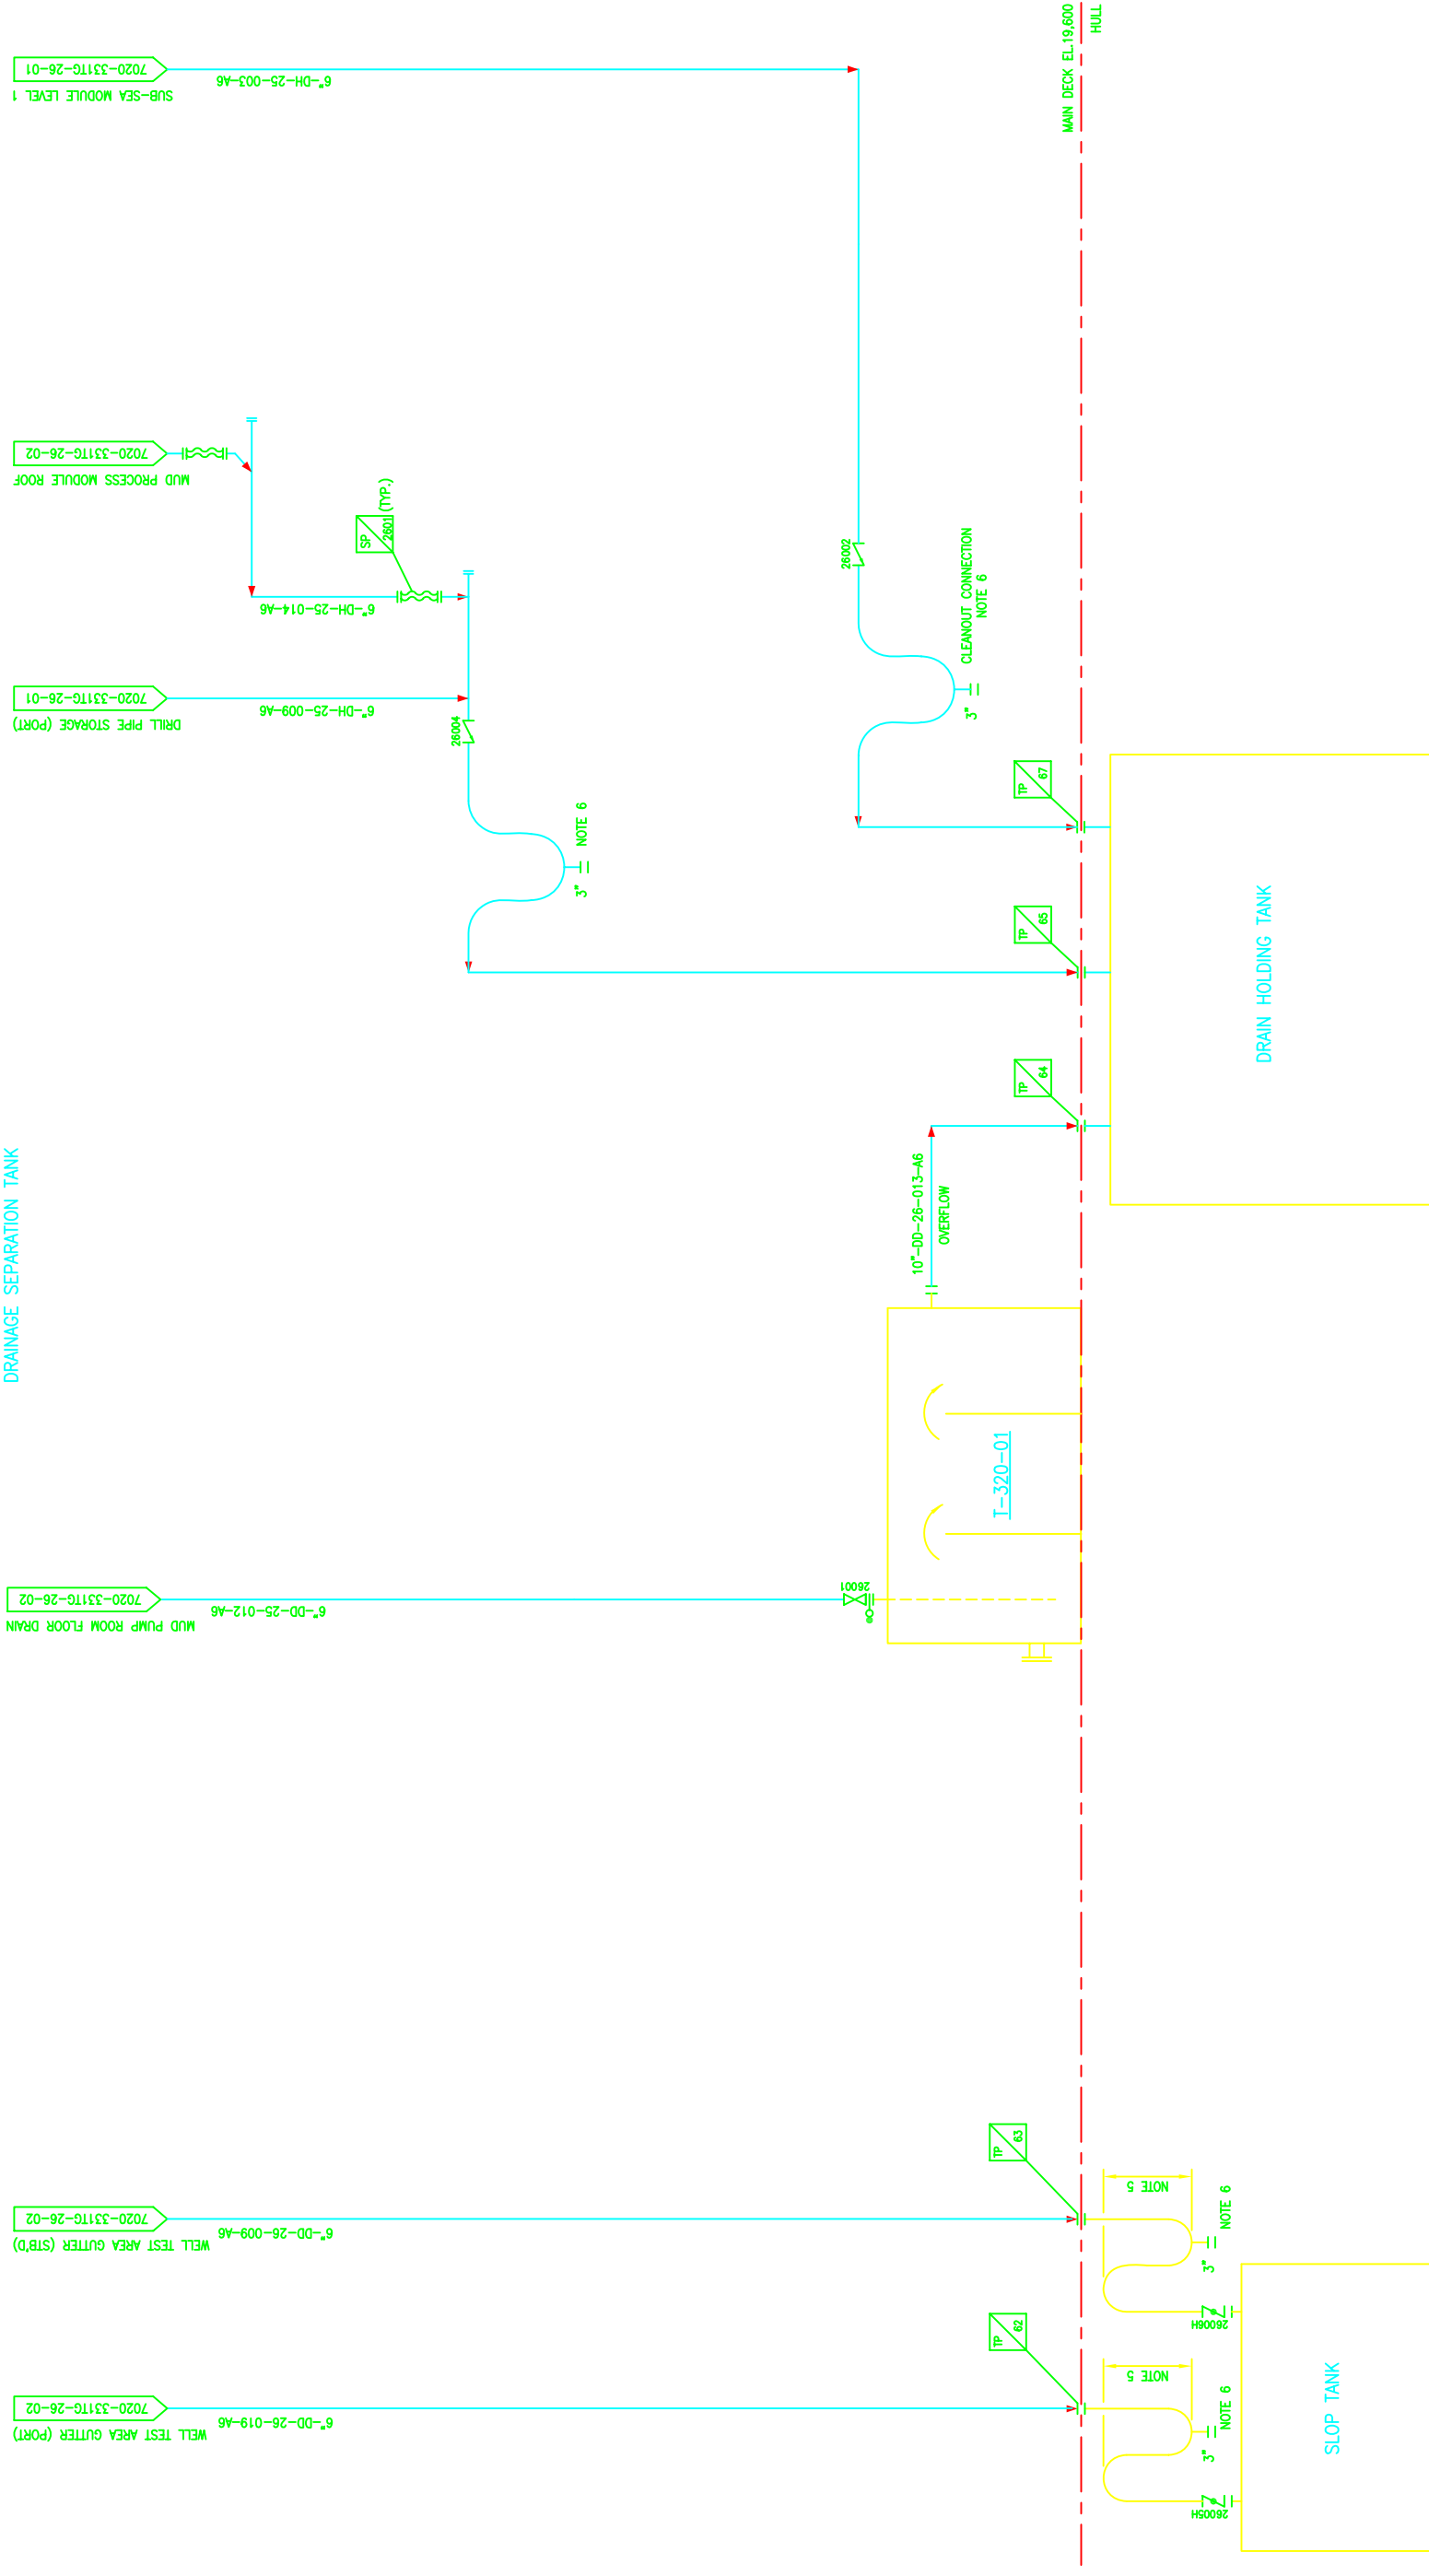

| REVISION | ISSUE | DATE | ORIG | CHK | ENG | RDS APP | SHI APP | REFERENCE DRAWINGS | NOTES |
|----------|-------------------------|----------|-----------|-----|-----------|---------|---------|--------------------|-------|
| 2 | AS-BUILT | | | | | | | | |
| 1 | ISSUED FOR CONSTRUCTION | 14/07/00 | KHS | WSH | | | | | |
| 0 | ISSUED FOR CONSTRUCTION | 03/11/99 | J.P. PARK | | Y.B. SHIM | | | | |
| B | ISSUED FOR APPROVAL | 29/03/99 | CP | JS | JS | AM | | | |
| A | ISSUED FOR I.D.C. | 28/01/99 | CP | JS | JS | ME | | | |
| | | 15/01/99 | Y.H.JUNG | JS | JS | AM | | | |

| DRAWING NUMBER | TITLE |
|------------------|---------------------------|
| 7020-331TG-01-01 | P&ID LEGEND SHEET 1 OF 2 |
| 7020-331TG-02-01 | P&ID LEGEND SHEET 2 OF 2 |
| 7020-331TG-26-01 | DRAIN SYSTEM SHEET 1 OF 3 |
| 7020-331TG-26-02 | DRAIN SYSTEM SHEET 2 OF 3 |

| CLIENT | PRODUCT | DESIGNED BY | CHECKED BY | SCALE | N.T.S. | DATE | DESIGNED BY | CHECKED BY | SCALE | N.T.S. | DATE |
|---------------------------------------|-----------|-------------|------------|-------|--------|----------------------|-------------|------------|-------|--------|------|
| R&B FALCON CORPORATION HOUSTON, TX | HULL 1300 | Y.H.JUNG | Y.H.JUNG | A1 | | 7020-331TG-26-03.DWG | Y.H.JUNG | Y.H.JUNG | | | |

| REVISION | ISSUE | DATE | ORIG | CHK | ENG | RDS APP | SHI APP |
|----------|-------------------------|----------|-----------|-----|-----------|---------|---------|
| 2 | AS-BUILT | | | | | | |
| 1 | ISSUED FOR CONSTRUCTION | 14/07/00 | KHS | WSH | | | |
| 0 | ISSUED FOR CONSTRUCTION | 03/11/99 | J.P. PARK | | Y.B. SHIM | | |
| B | ISSUED FOR APPROVAL | 29/03/99 | CP | JS | JS | AM | |
| A | ISSUED FOR I.D.C. | 28/01/99 | CP | JS | JS | ME | |
| | | 15/01/99 | Y.H.JUNG | JS | JS | AM | |