

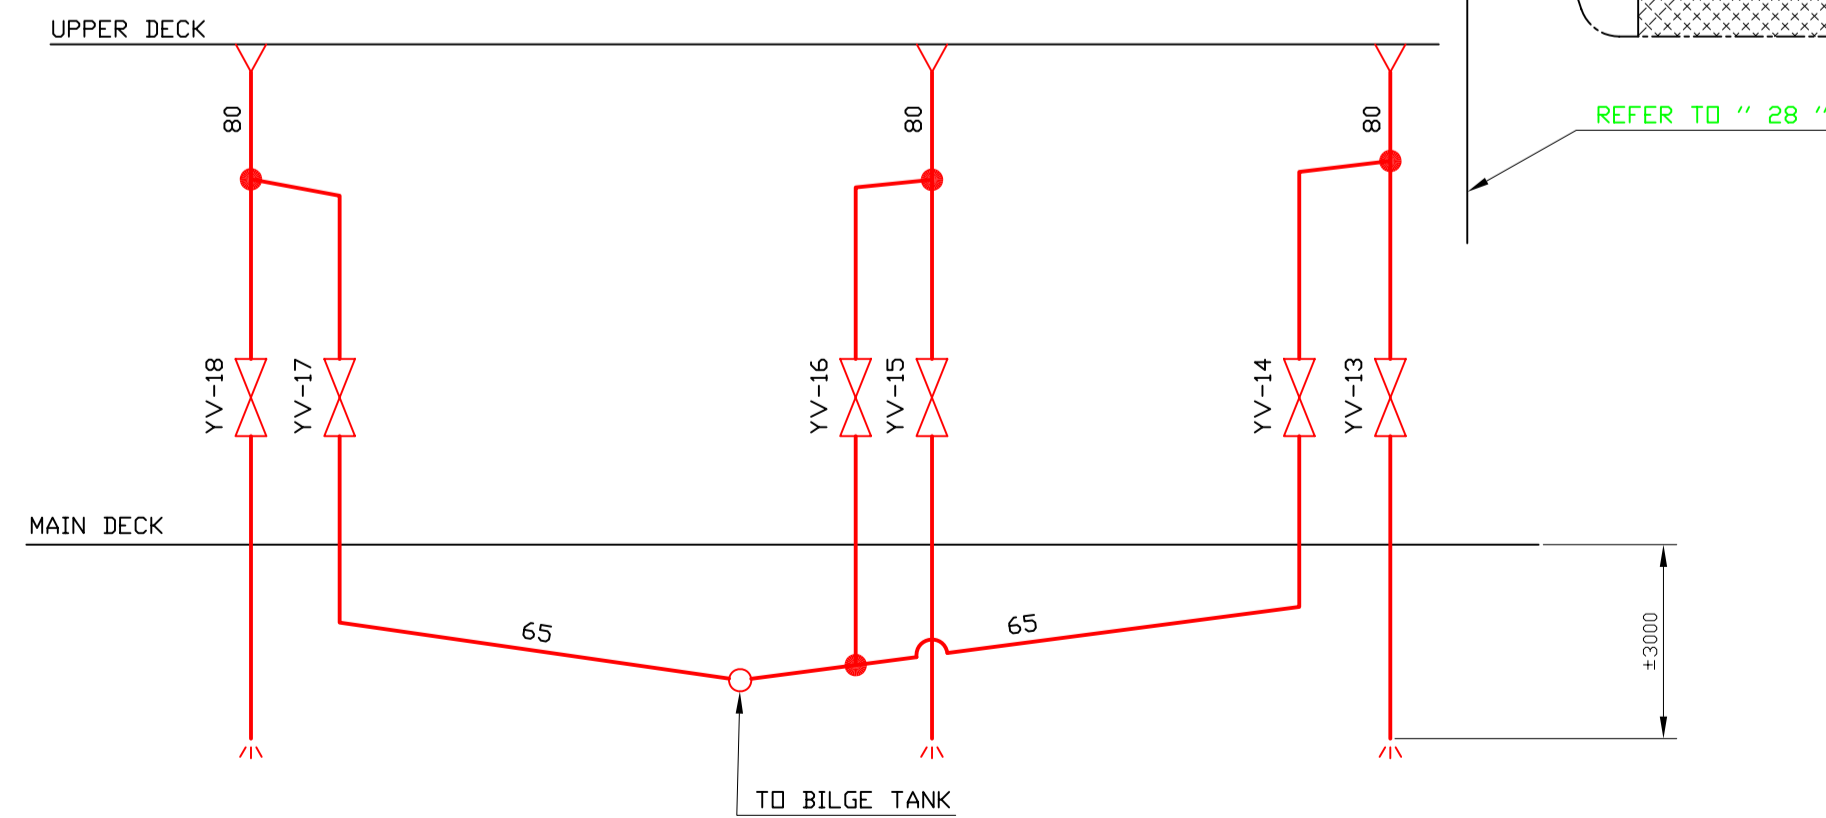
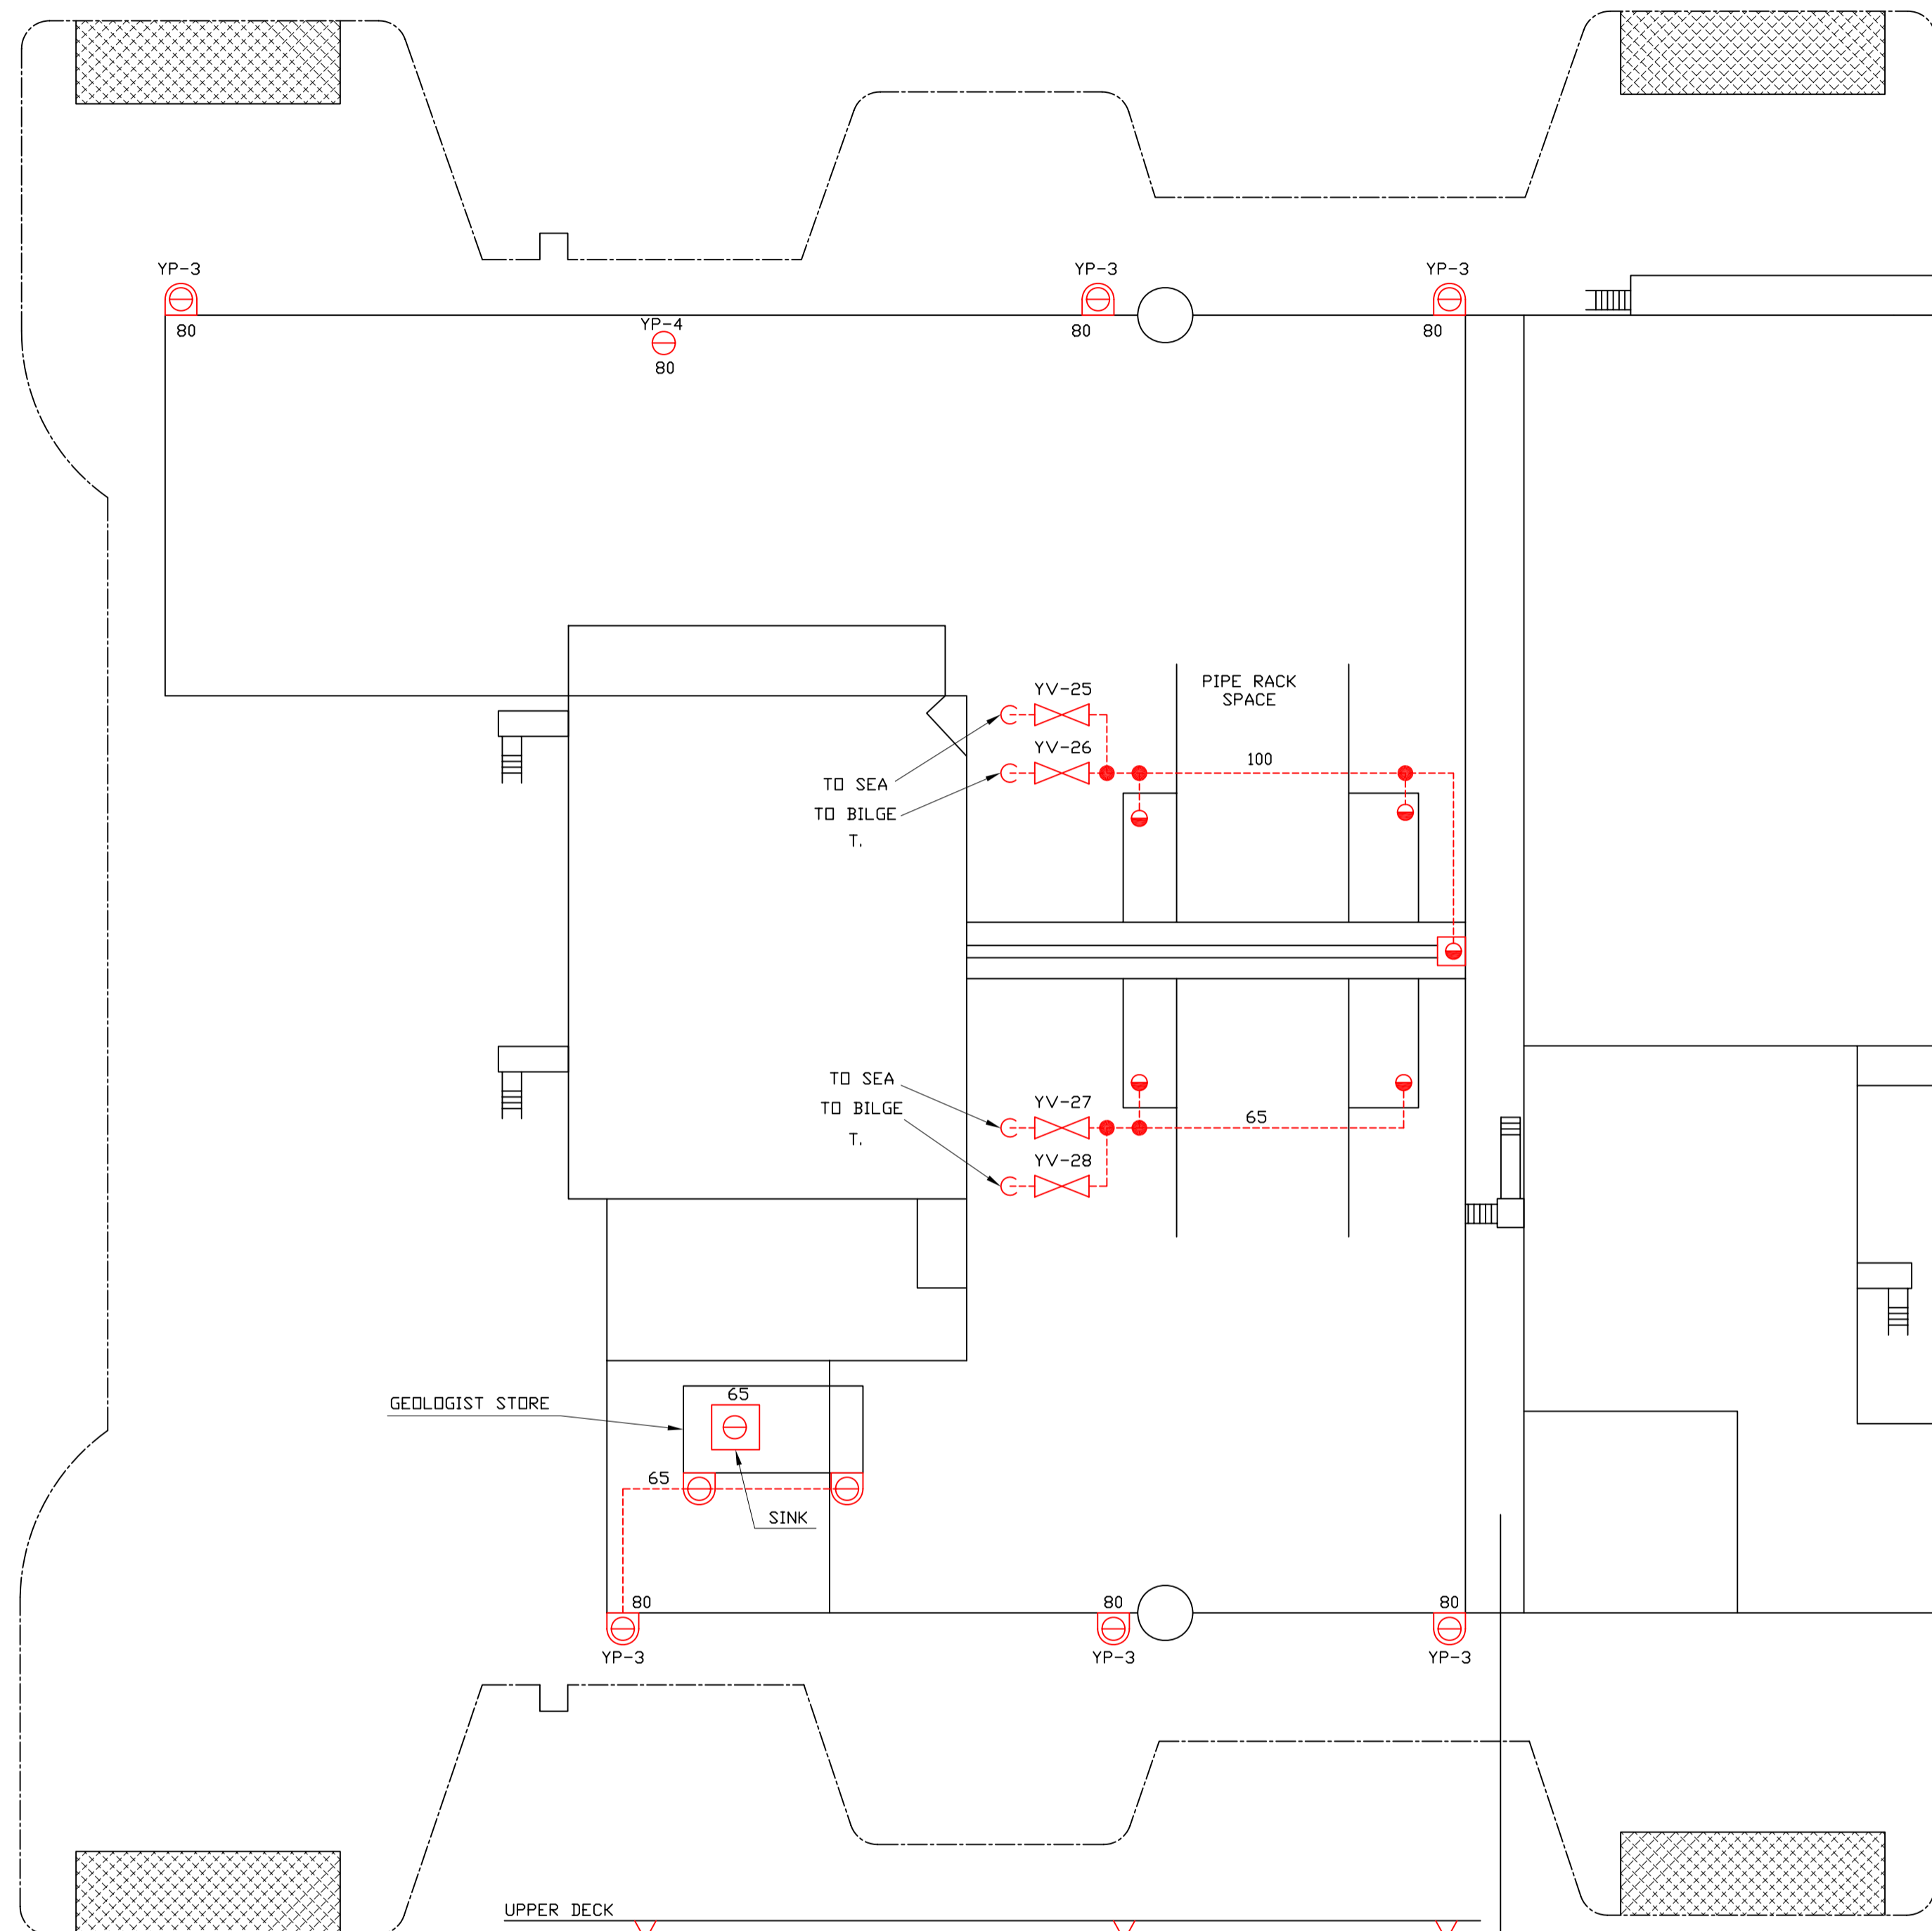



UPPER DECK PLAN

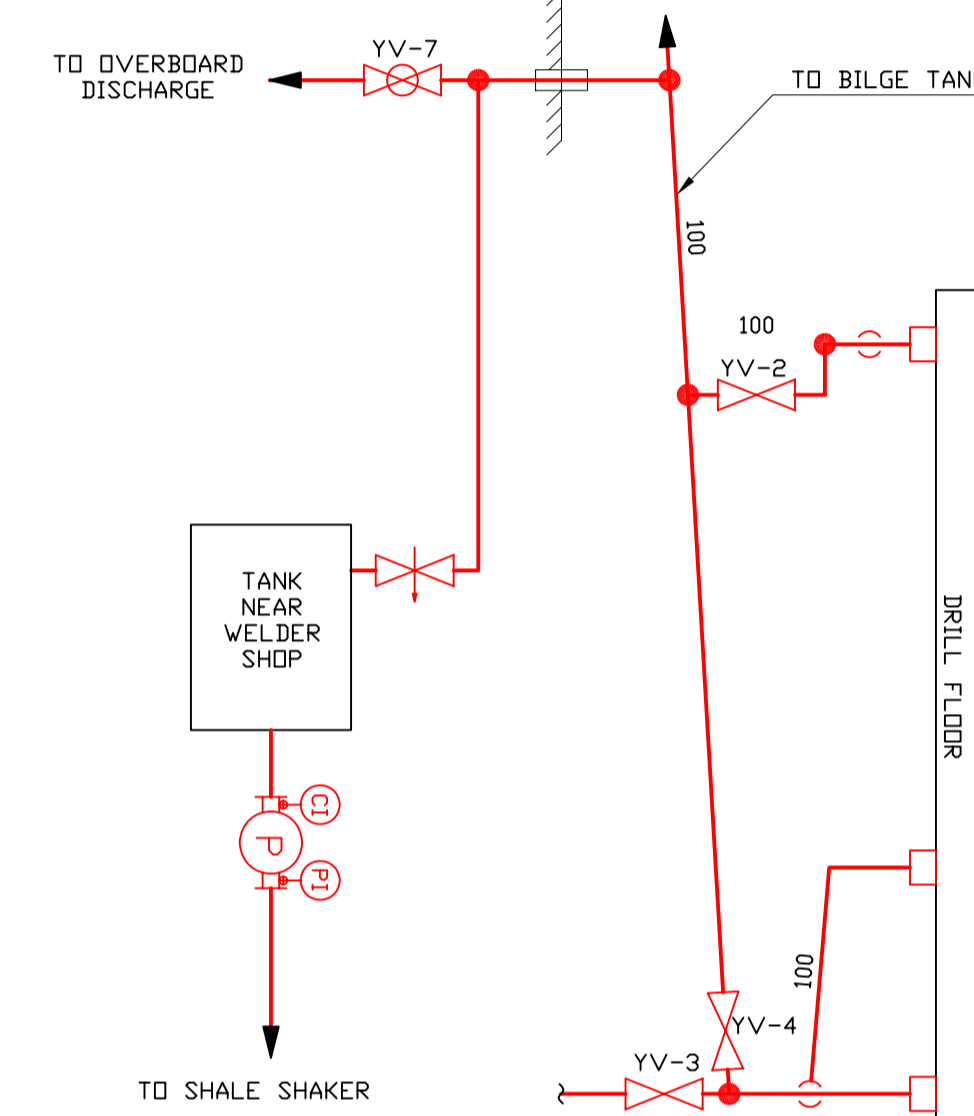


" A " SECTION

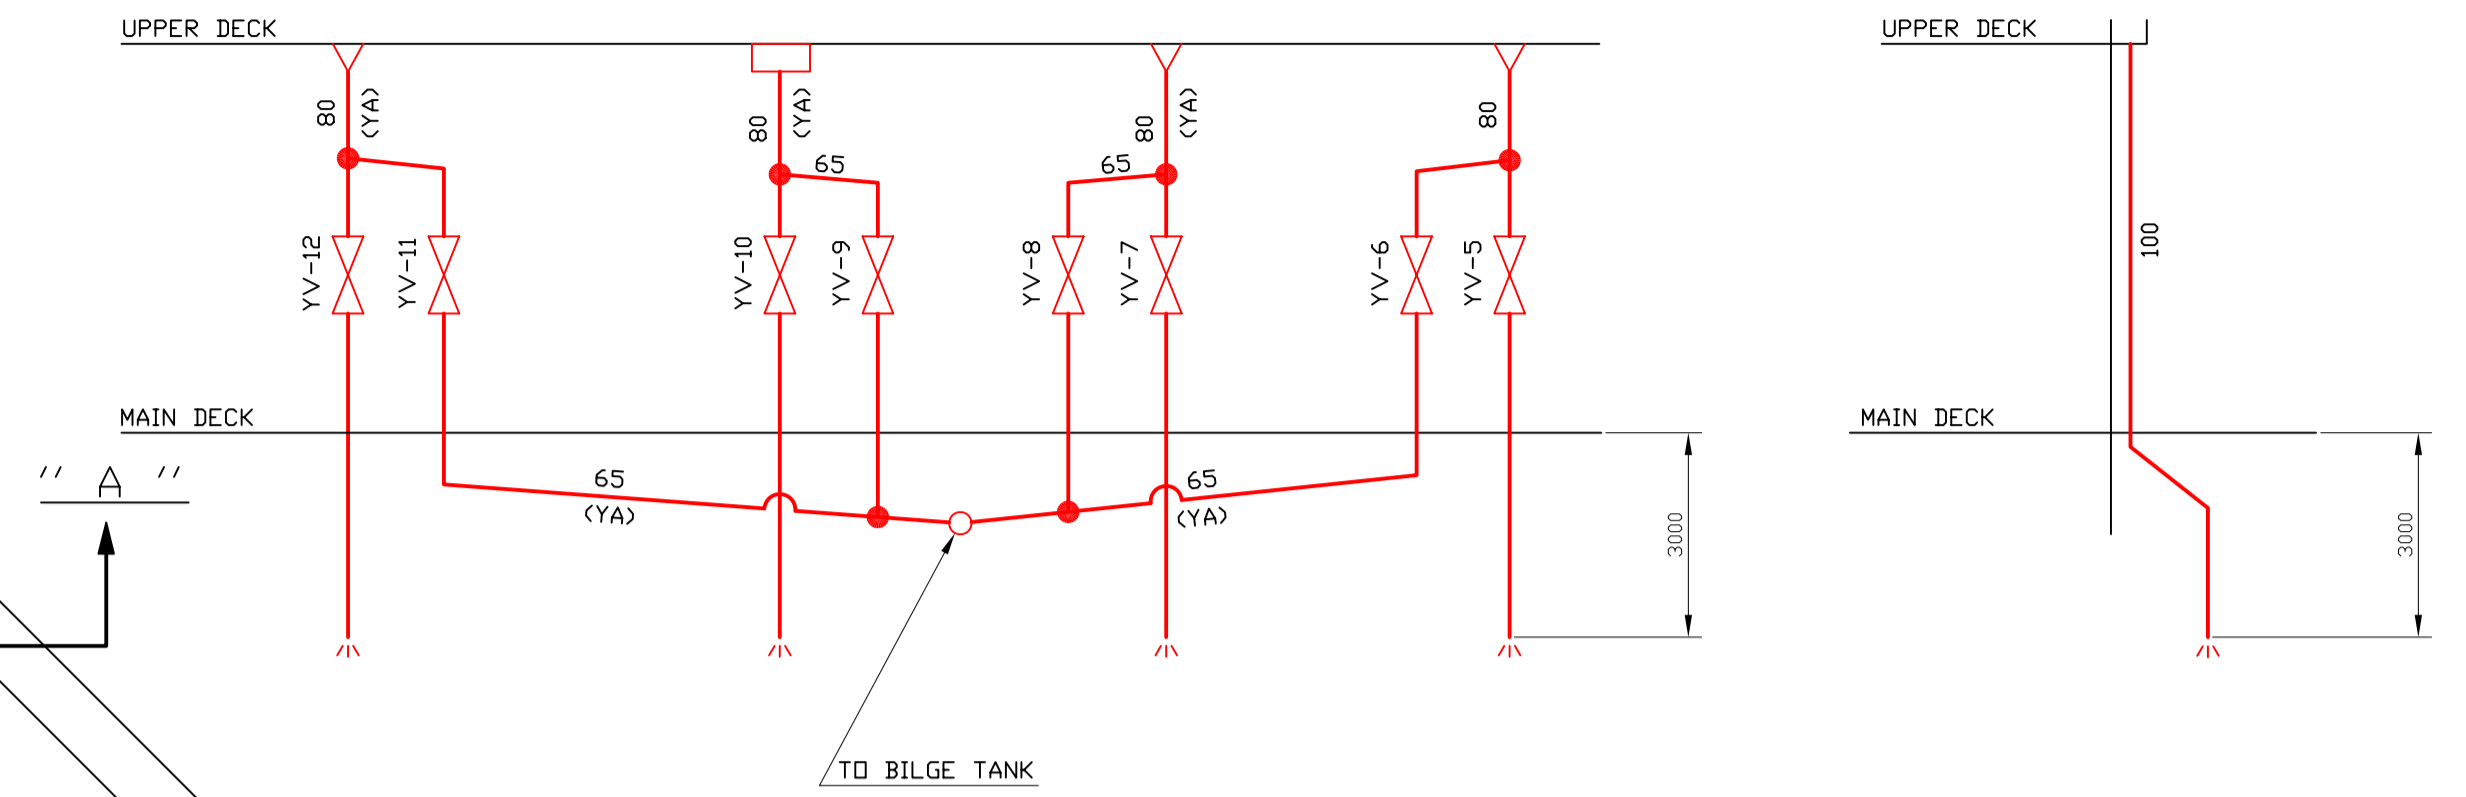

DRILL FLOOR PLAN

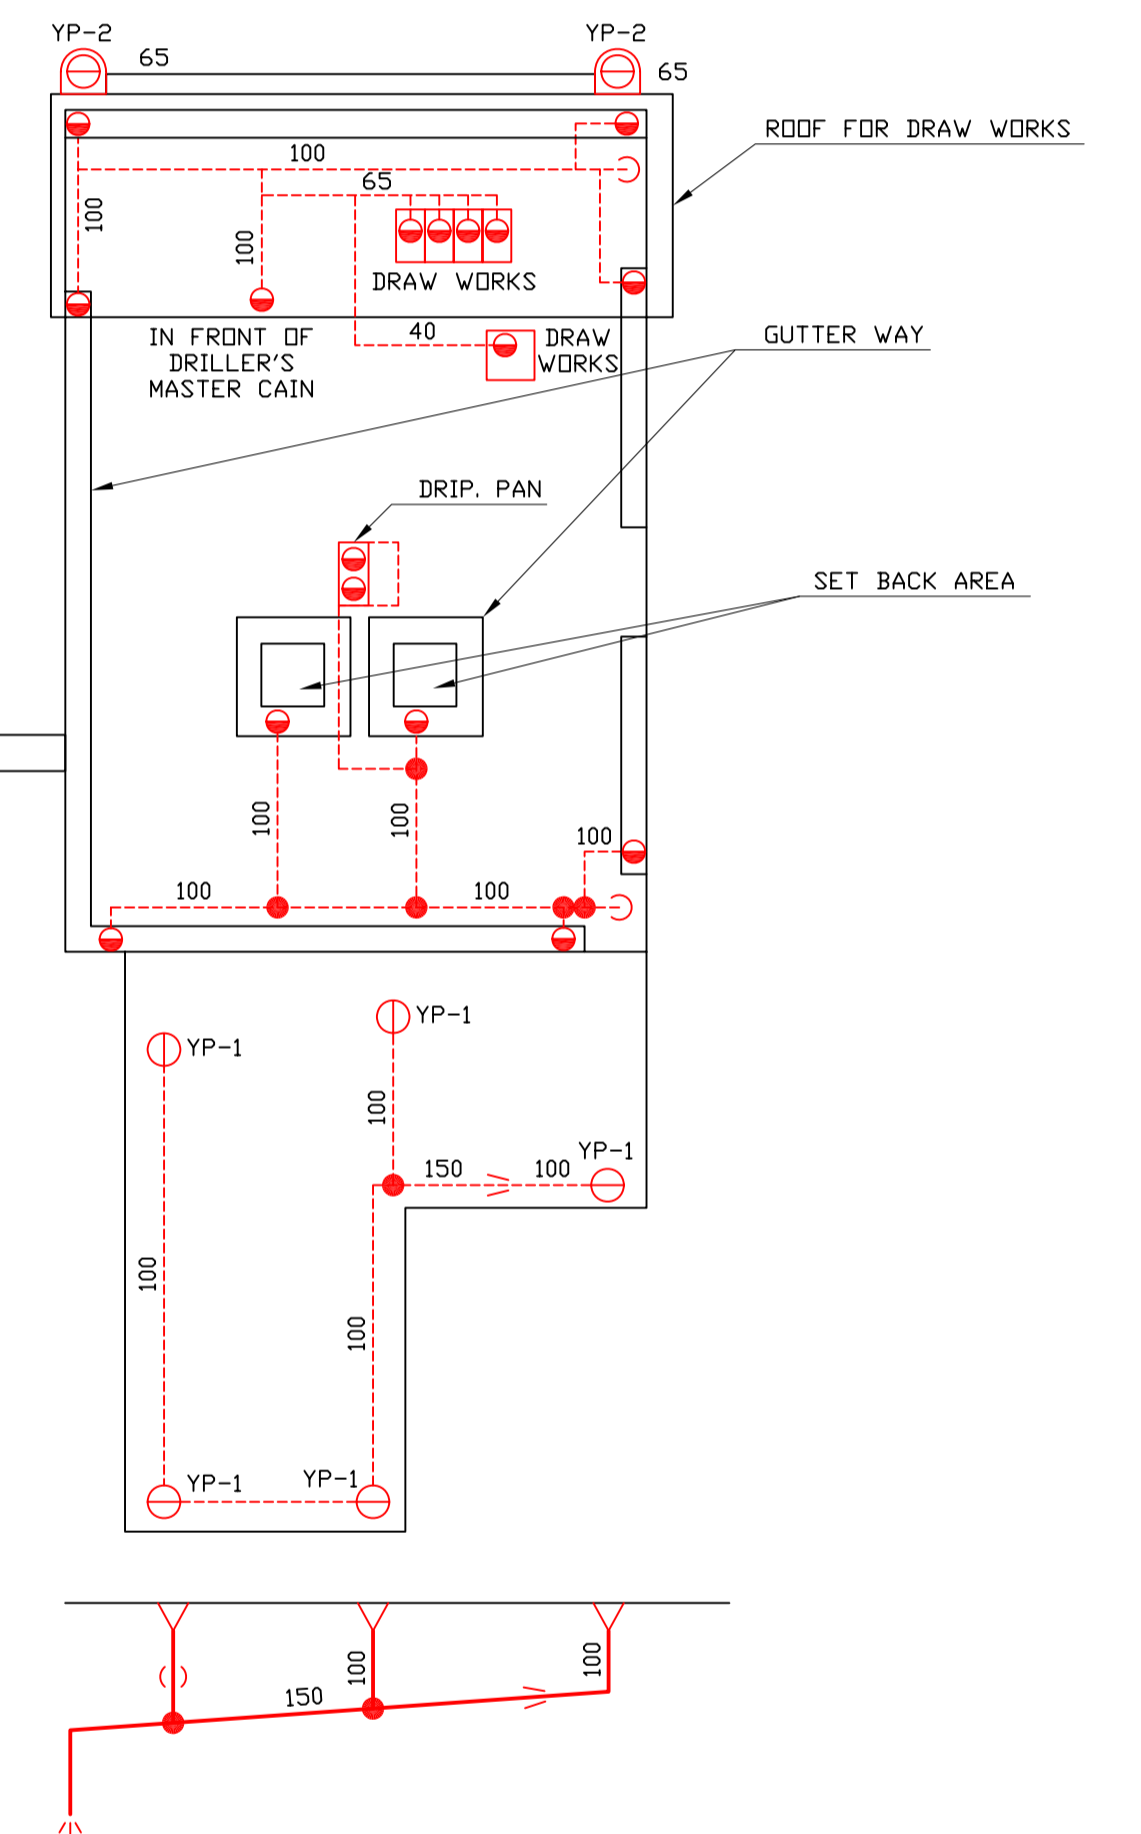

- DIRTY DRAIN PIPE
- CLEAN DRAIN PIPE
- ⊖ MARK SCUPPER
- PLAN () SHOWS ⊖ SCUPPER

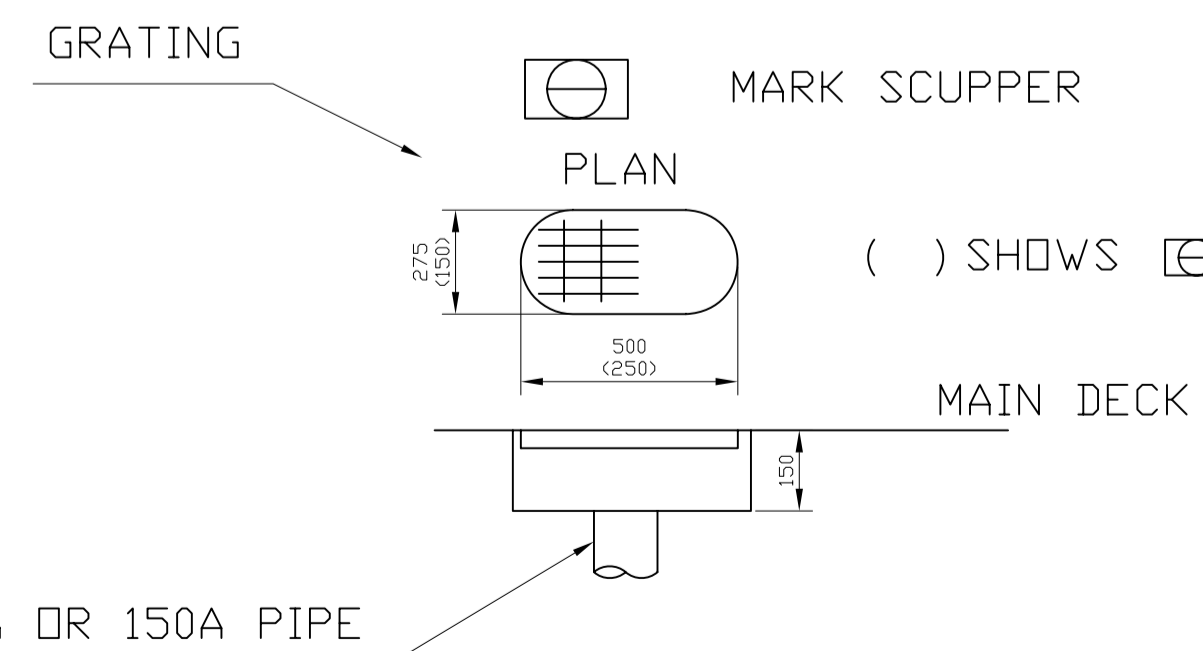

NOTE: ALL HOSE COUPLINGS ARE TO BE OF KAMLOOK TYPE

ISSU DU PLAN HITACHI N° K-1035/36-29

RIG : PRIDE SOUTH ATLANTIC		<p>16b, rue Grange-Dame-Rose 78140 VELIZY-VILLACOUBLAY FRANCE Tel: (33) 01.30.70.58.58 Fax: (33) 01.39.46.39.25</p>	
DESIGNATION : SCHEMATIC PIP. LAYOUT DRAINAGE SYSTEM EXCEPT FOR ACCOMODATION			
<input checked="" type="checkbox"/> ZI <input type="checkbox"/> PRE CONCEPT <input type="checkbox"/> PRELIMINARY <input type="checkbox"/> CONTRACT	<input type="checkbox"/> FOR ANALOGY <input type="checkbox"/> PRELIMINARY <input type="checkbox"/> INFORMATION	<input type="checkbox"/> COMMENT <input type="checkbox"/> APPROVAL <input checked="" type="checkbox"/> CONSTRUCTION	SCALE : NONE DATE : 11.11.2005 DRAWN : ASNETTO APPR'D : M. BONIFAY
EMISSION A 11.11.05 ASNETTO REVISION N° DATE BY		N° PS 0803-2/2 A	