

20-#B#-***A/B/C/D

20-#B#-001

20-#B#-002


20-#B#-003

SIZE: x

SIZE: x

SIZE: x

SIZE: x

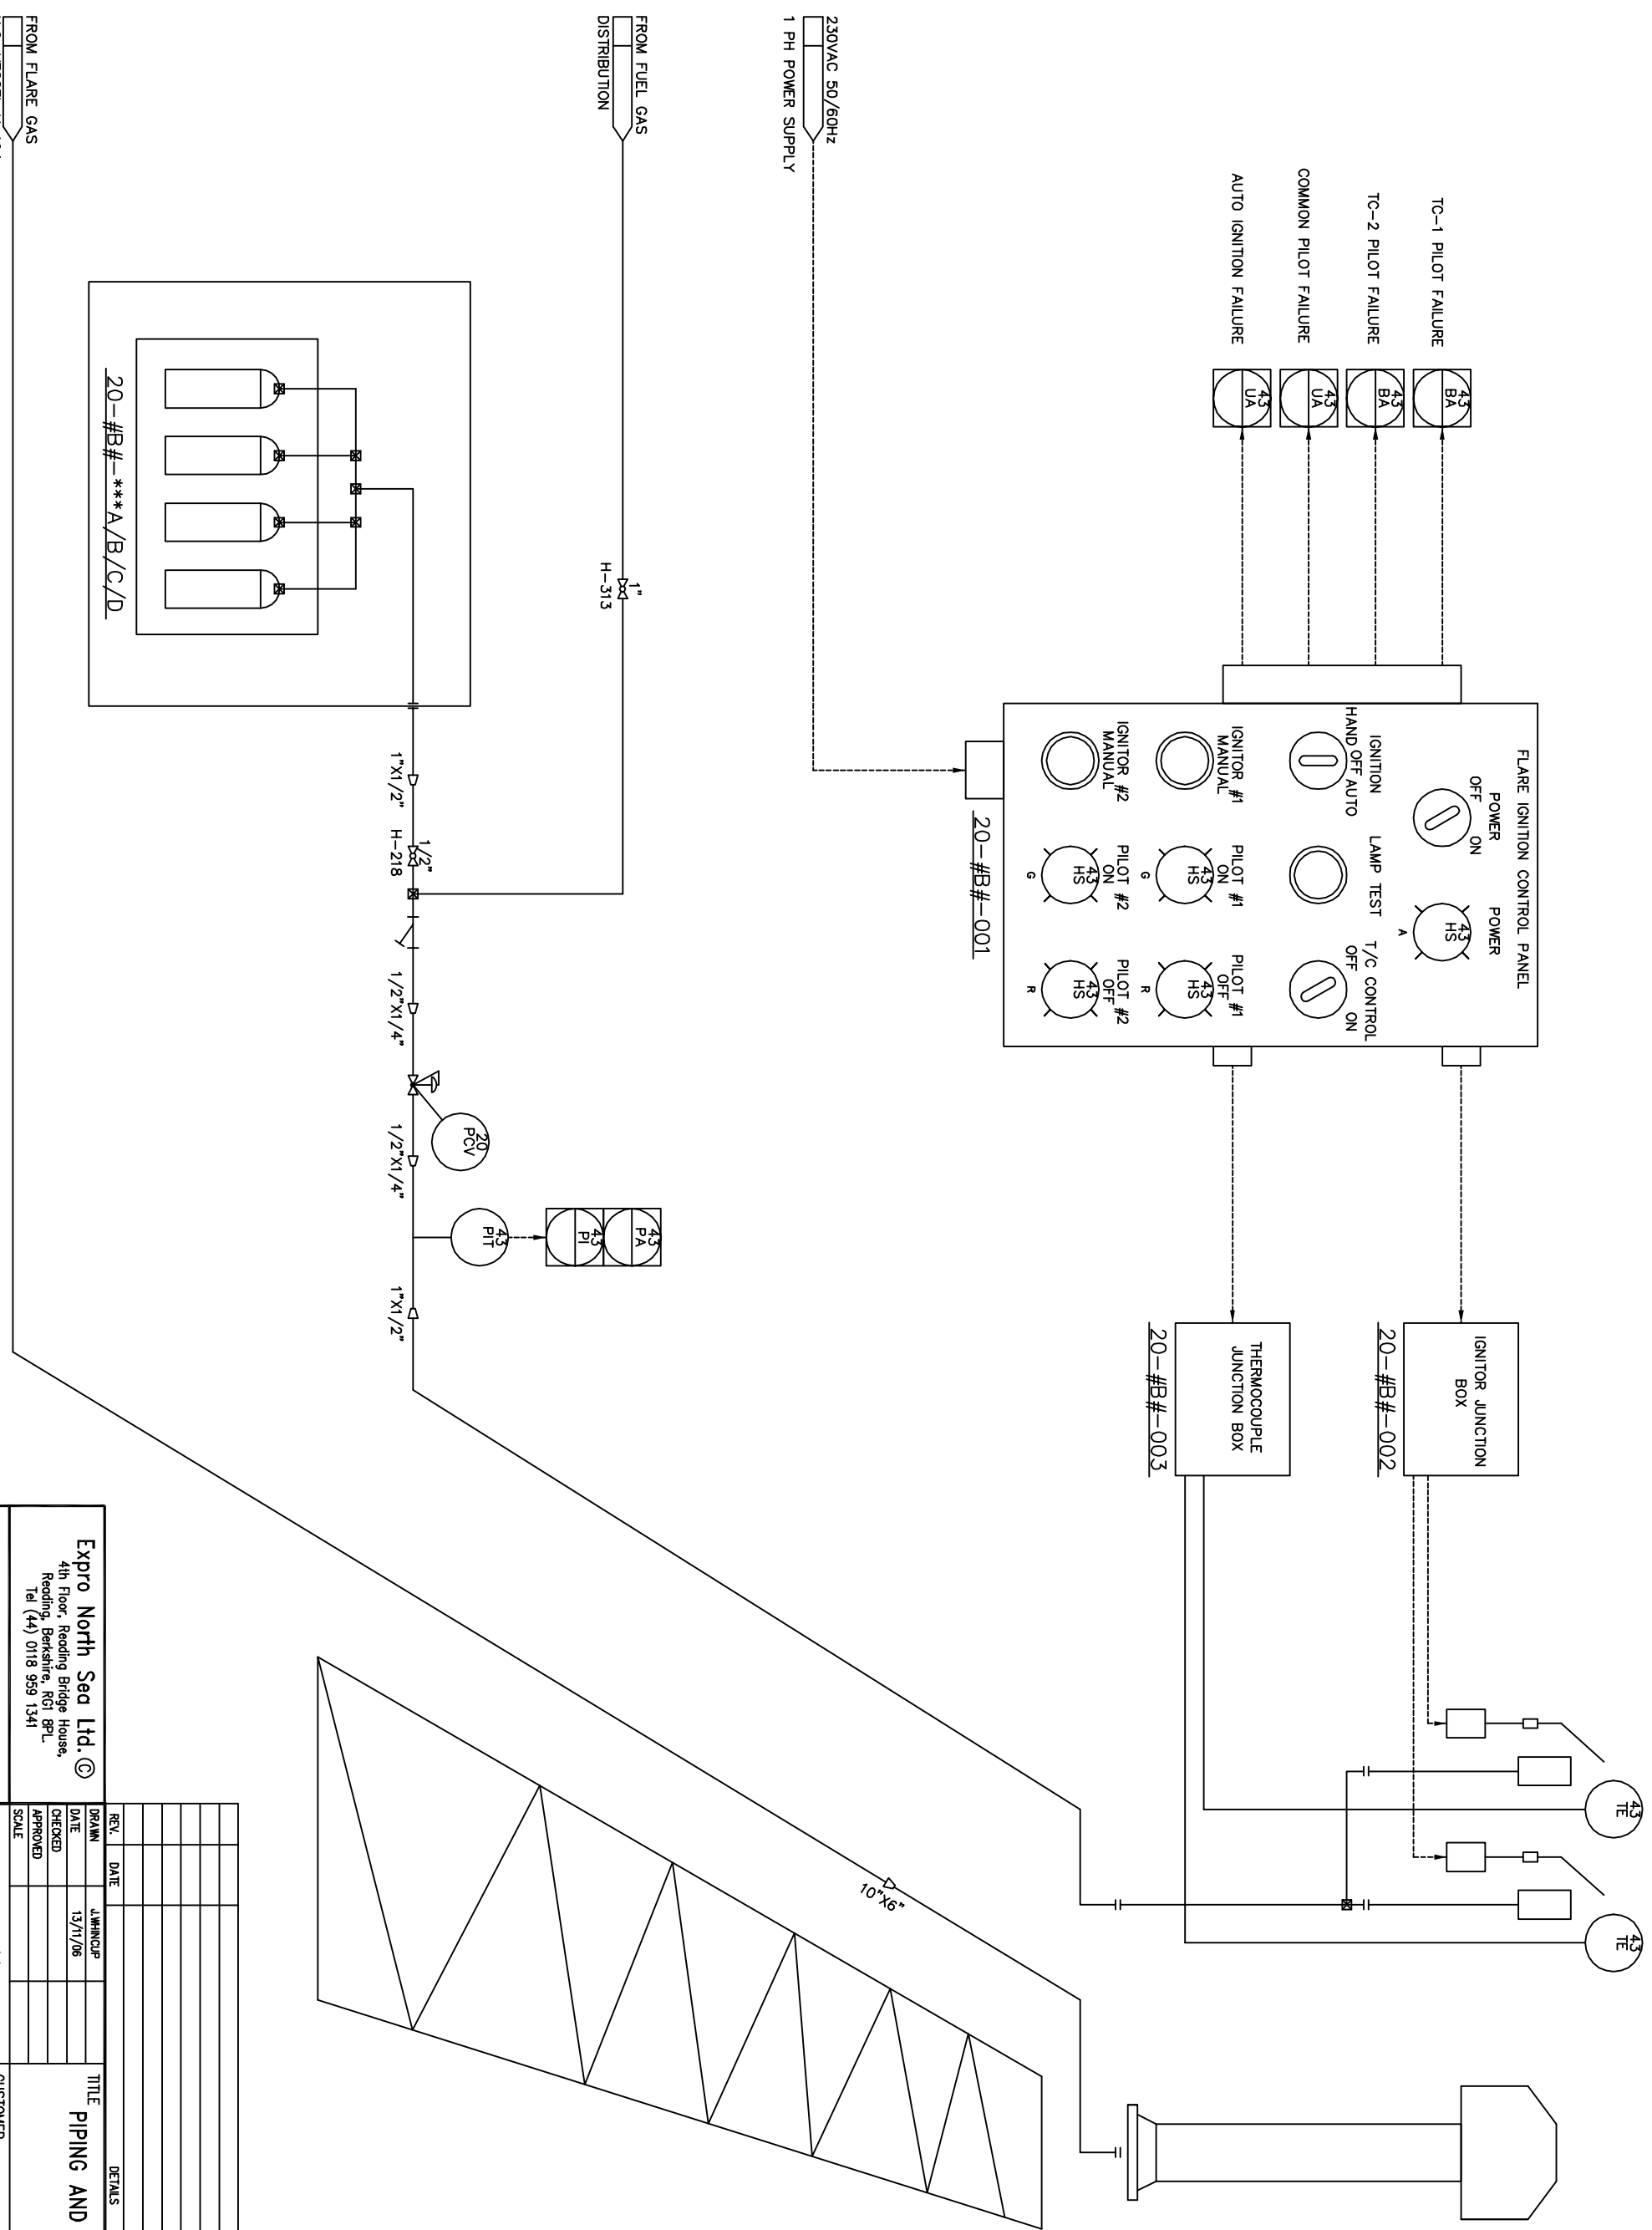

Expro North Sea Ltd. ©
 4th Floor, Reading Bridge House,
 Reading, Berkshire, RG1 9PL
 Tel (44) 0118 959 1341

© Design Rights EXPRO NORTH SEA LIMITED. This document is the property of EXPRO NORTH SEA LIMITED and is not to be reproduced, communicated to a third party or used in any manner whatsoever without the prior written consent of EXPRO NORTH SEA LIMITED.

REV.	DATE	BY	CHKD	APPROV.

TITLE: PIPING AND INSTRUMENTATION DIAGRAM
 CUSTOMER: PETROBRAS SRI
 PROJECT No.:
 DRAWING No.:
 REV: 0



06-PE0003A-5 2015