


CRUDE-CRUDE EXCHANGERS (2x50%)		
TAG	E-T6201A/B	
DESIGN DUTY (kW)		
	HOT SIDE	COLD SIDE
DESIGN PRESSURE bar(g)	FV/15	FV/15
DESIGN TEMPERATURE (°C)		
OPERATING PRESSURE bar(g)		
OPERATING TEMPERATURE (°C)		
MOC	TITANIUM	TITANIUM

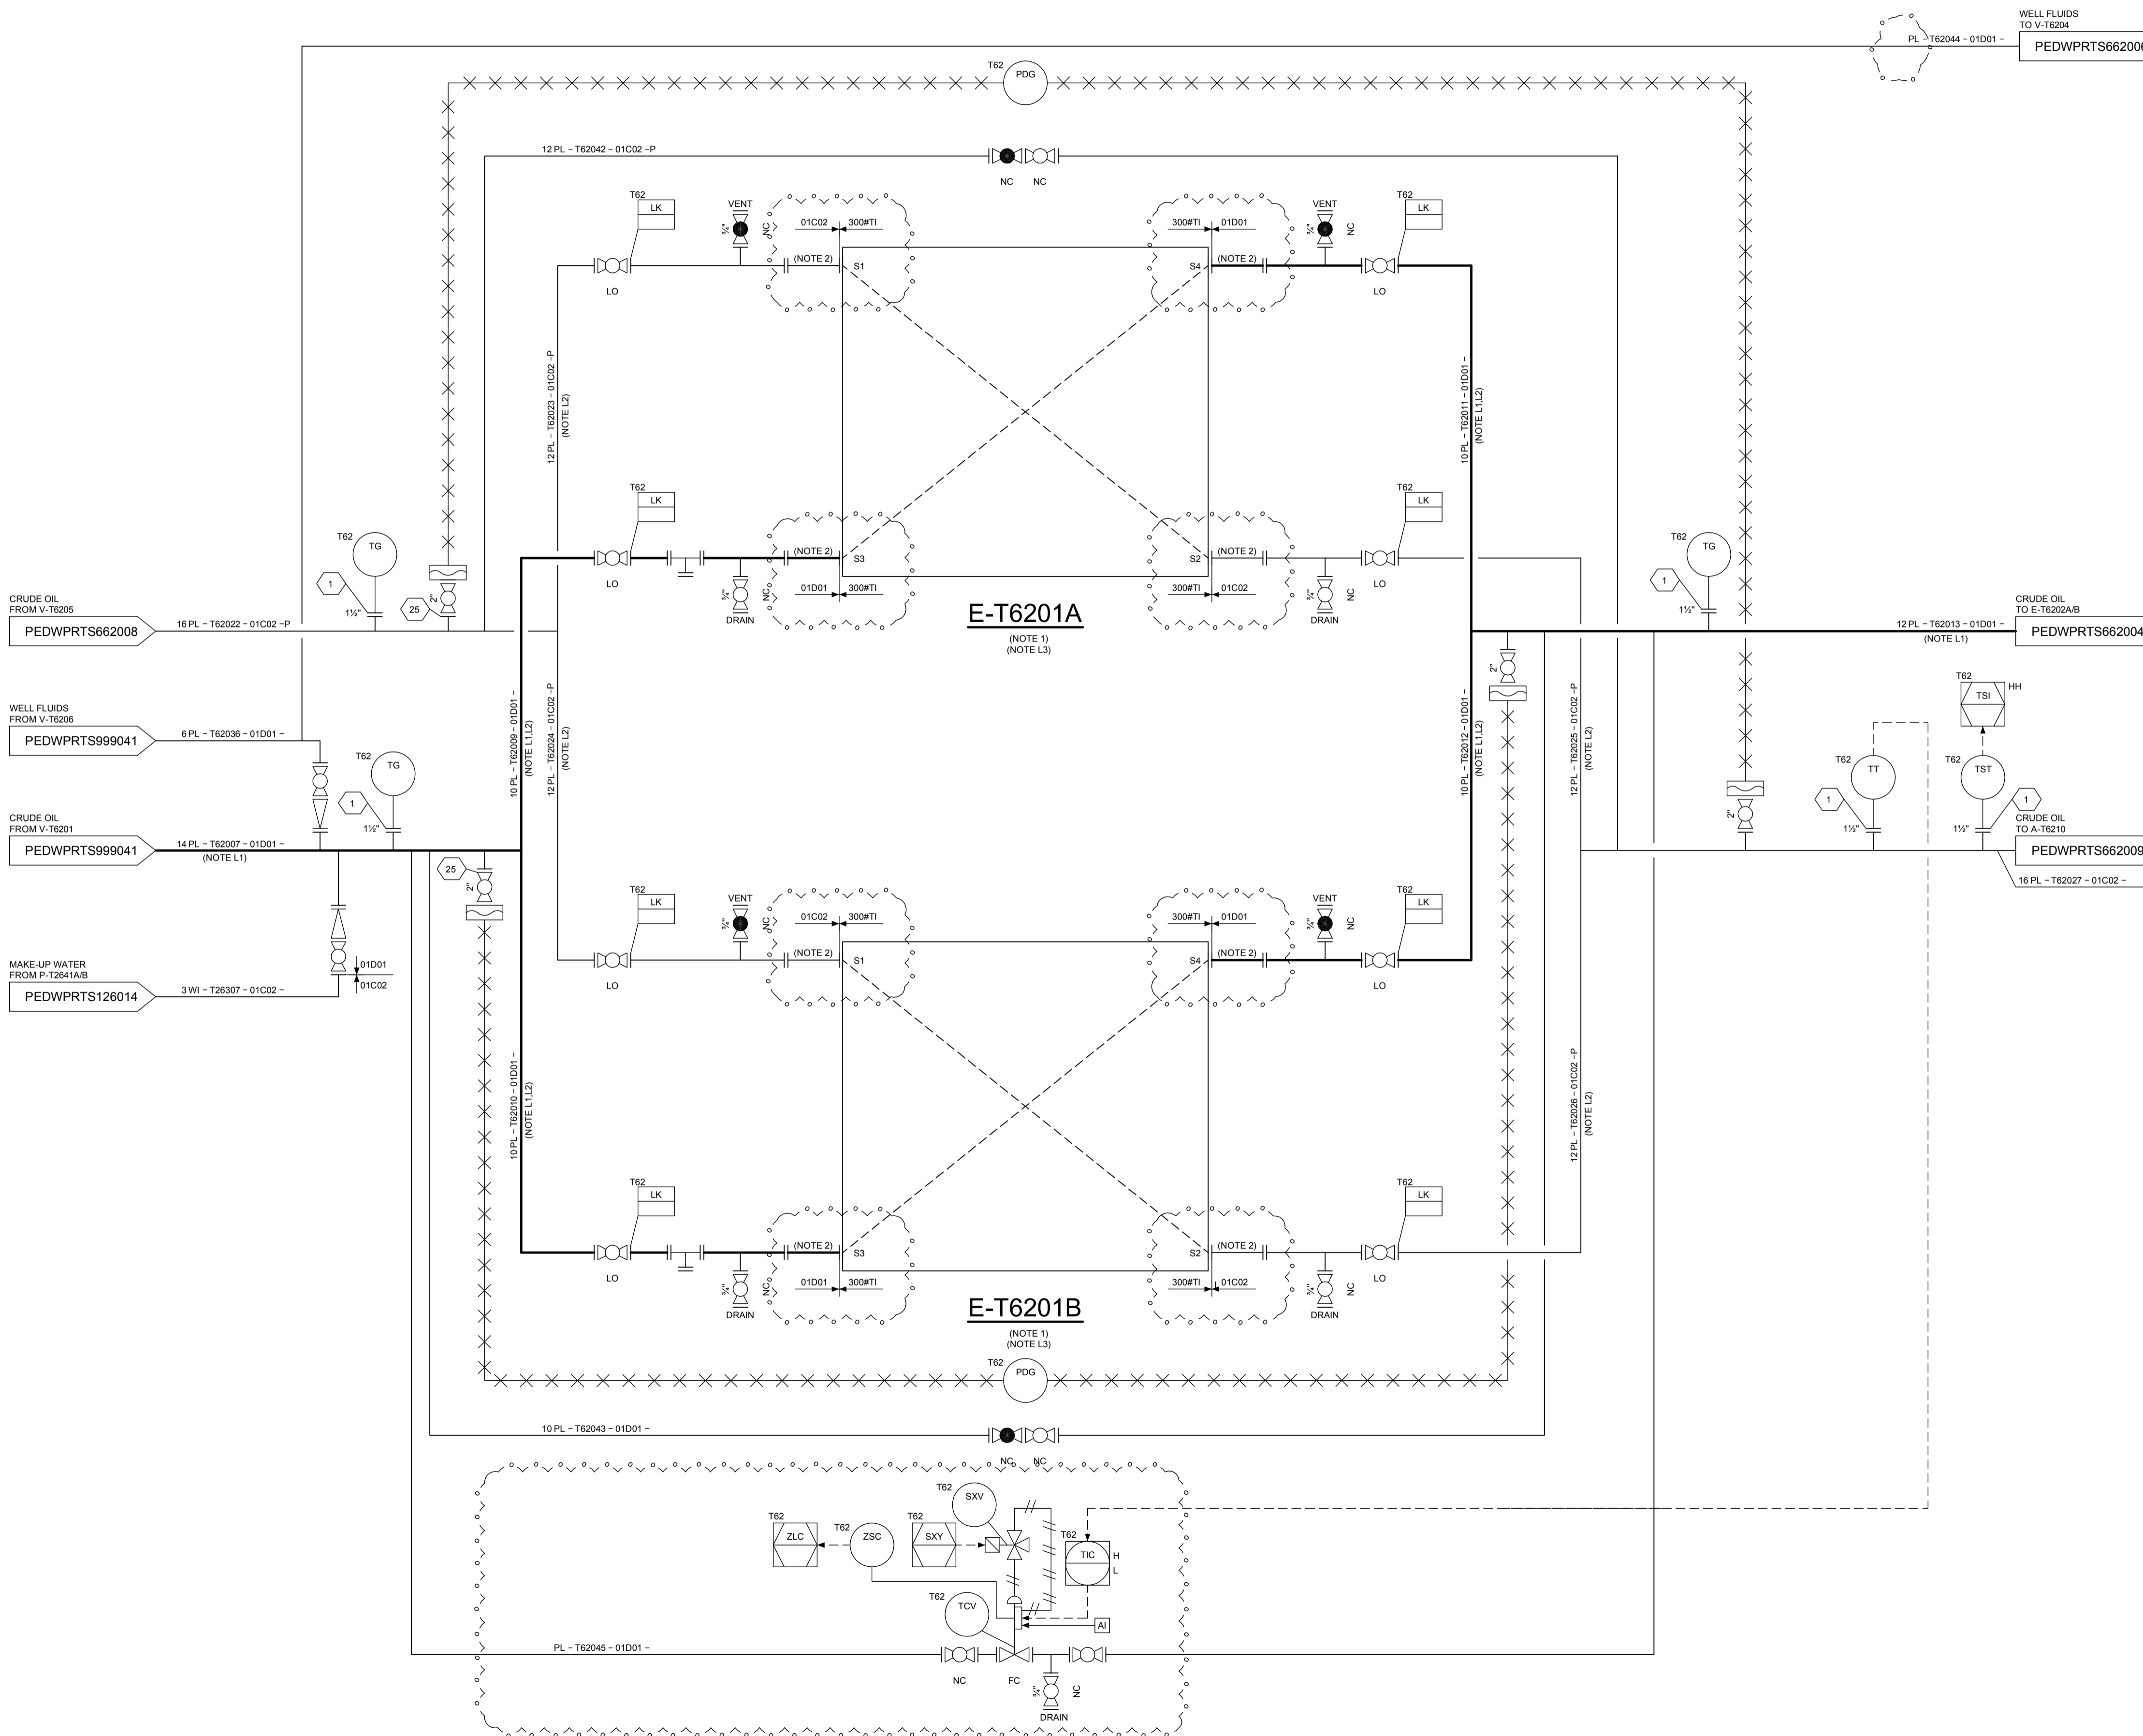

GENERAL NOTES	
ID	DESCRIPTION
1	HEAT EXCHANGER SHALL BE DRAINED IMMEDIATELY UPON BLOCK-IN TO AVOID DEPRESSURIZATION DUE TO THERMAL EXPANSION
2	REMOVABLE SPOOL

LAYOUT NOTES	
ID	DESCRIPTION
L1	NO POCKETS
L2	INLET & OUTLET LINES SHALL BE SYMMETRICAL TO ENSURE EQUAL FLOW DISTRIBUTION
L3	LOCATION OF NOZZLES IS SCHEMATIC. FOR EXACT LOCATION REFER TO G.A. DRAWING

REFERENCE DOCUMENTS		
ID	SBM DOC. NUMBER	DESCRIPTION
1	PEDWPRPG999003	FPSO - PIPING LEGEND - P&ID
2	PEDWPRPG999004	FPSO - PIPING IDENTIFICATION LEGEND - P&ID
3	PEDWPRPG999005	FPSO - INSTRUMENTATION LEGEND - P&ID
4	PEDWPRPG999006	FPSO - EQUIPMENT LEGEND - P&ID
5	PEDWPRPG999007	FPSO - TYPICAL DETAILS - P&ID 1
6	PEDWPRPG999008	FPSO - TYPICAL DETAILS - P&ID 2
7	PEDWPRPG999009	FPSO - TYPICAL DETAILS - P&ID 3
8	PESDPITS999120	TOPSIDES - PIPING DETAIL - SPECIFICATION

LEGEND	
	CLOUD INDICATING ITEM ON HOLD

HOLDS	
ID	DESCRIPTION
1	OPERATING / DESIGN CONDITIONS
2	CONTROL VALVE SIZES
3	CONNECTIONS HEAT EXCHANGERS

TS062

Revision	Date (dd-MMM-yy)	Description of revision	Prepared by	Engineering checked by	Approved by LE	Approved by EPM
11	29-DEC-11	INTER DISCIPLINE CHECKING				

	Engineering Subcontractor: SINGLE BODY MICROELECTRONICS INC. P.O. Box 152 5, route des Fougères CH-1723 Mably Switzerland Tel: +41 26 439 99 20 Fax: +41 26 439 99 39	© Copyright SBM Offshore N.V. 2011 All rights reserved. SBM Offshore N.V. or its affiliates. This document and its contents are the confidential property of SBM Offshore N.V. or its affiliates and as such this document, or any part thereof, may not be made known, be copied, or be multiplied or in any other way used without the express permission of SBM Offshore N.V. or its affiliates.	PETROBRAS NETHERLANDS B.V.
	Client: PETROBRAS NETHERLANDS BV Project: FPSO CIDADE DE ILHABELA		
Title: TOPSIDES CRUDE-CRUDE EXCHANGERS P&ID			

Format	Projection Method	Scale	Project Number	Document Number	Sheet No./Sheets	Revision
A1		N.T.S.	HI 39520	PEDWPTS662003	1 / 1	11