

SPECIFICATION CODE
EXHIBIT A - 3.7

12			
11			
10			
9			
8			
7			
6			
5			
4			
3			
2			
1			
ITEM	COMPANY NAME	DRAWING NO. OR DOCUMENT TITLE	REV

LIST OF REFERENCED DRAWINGS AND DOCUMENTS USED FOR DRAWINGS

OWNER									
CLASS									
PJD									
PJM									
CONSTR.MGR									
COMM.MGR									
OFFSHORE									
PROCUREMENT									
ME									
HS									
PF			B	23/01/2015	Re-Issued for Comments	MK	PSA	JaD	
HP			A	25/Nov/14	Issued for Comments	SH	MND	PL	
HV			REV	DATE	ALTERATIONS	MOD'D	CHK'D	APPR'D	
QA/QC			THIS DOCUMENT AND THE INFORMATION CONTAINED WITHIN COMPRISE PROPRIETARY INFORMATION OWNED SOLELY BY JURONG SHIPYARD PTE LTD. THIS DOCUMENT IS PROVIDED SUBJECT TO THE PROVISION THAT THE INFORMATION HEREIN WILL NOT BE DISCLOSED OR REPRODUCED UNLESS SPECIFICALLY AUTHORISED IN WRITING BY JURONG SHIPYARD PTE LTD NOR WILL BE USED IN ANY WAY DETRIMENTAL TO OR IN COMPETITION WITH INTEREST OF JURONG SHIPYARD PTE LTD. THIS DOCUMENT, REPRODUCTIONS PREVIOUSLY AUTHORISED IN WRITING AND ASSOCIATED INFORMATION SHALL BE RETURNED WHEN THEY HAVE SERVED THEIR INTENDED PURPOSES, OR ON DEMAND.						
JIS									
SMOE									

ENGINEERING DEPARTMENT	PM		 JURONG SHIPYARD PTE LTD <small>(A subsidiary of SembCorp Marine Ltd)</small> SINGAPORE ENGINEERING DEPARTMENT xx SECTION	 <small>MANUT. SYS. RYA C 148</small> ISO 9001 <small>Certificate Number: 2743</small>	OWNER:	 <small>OIL & GAS</small>		
	BD				SUB-CON:	 <small>LONDON MARINE CONSULTANTS</small>		
	HC				PROJECT:	FPSO Pioneiro de Libra		
	MF				JOB NO.:	22 - 0508		
	EF				OOGTK		OOGTK SFI:	
	PRO					OOGTK02-12-L-94-XA-000257-002	256	
	PI	PROJ MGR			TMW <i>PP/AD</i>	SUB-CON DOCUMENT NO.:		
	HFA	SECT MGR			PSA <i>PSA</i>	8447-LMC-DWG-PRO-6125_A02		
	HFF	CHARG. ENG			TTM <i>TTM</i>	CLASS :		
	HV	CHECKER			PSA <i>PSA</i>	ABS		
EF	DRAWER	MK <i>MK</i>						
TOTAL	0	DATE DRAWN	23-Jan-15		JSPL DOCUMENT NO.:	REV	OOGTK DOC. STATUS CODE	
DISTRIBUTION		DATE ISSUED	23-Jan-15		0508-P-100-971-03-13-01-A	B	2	


DO NOT SCALE, IF IN DOUBT ASK

NOTES:

- 1. FOR NOTES REFER TO DRAWING No. 8447-LMC-PRO-DWG-6125-001.

HOLDS:

- 1. FOR HOLDS REFER TO DRAWING No. 8447-LMC-PRO-DWG-6125-001.

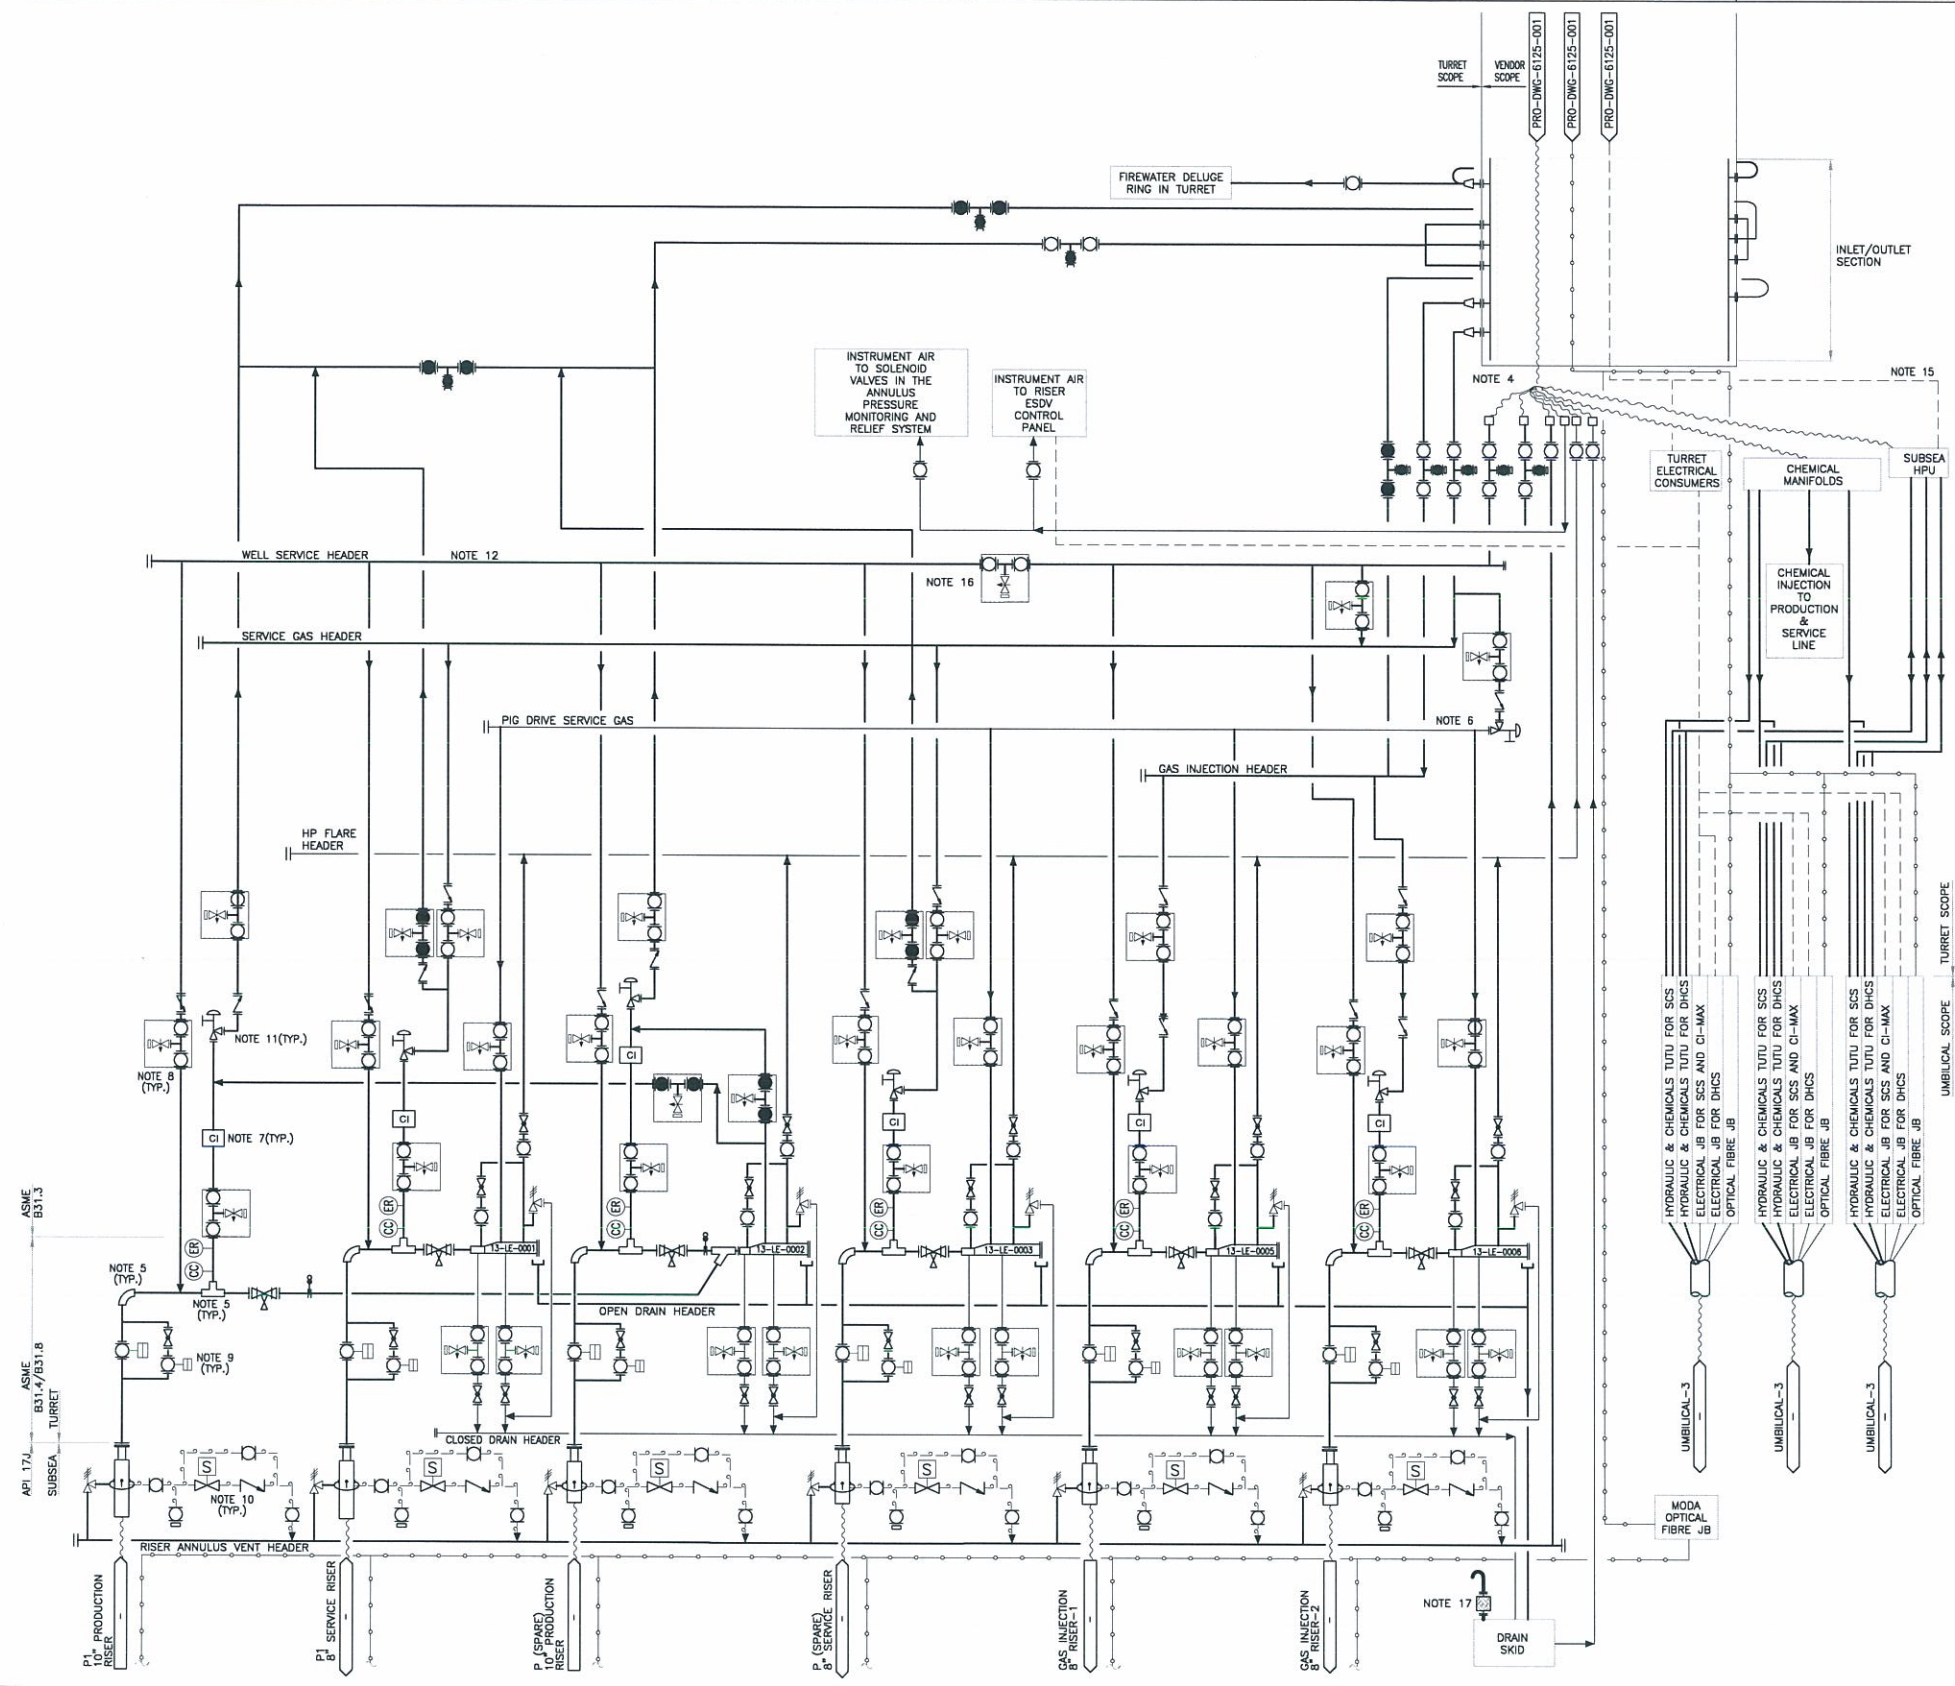

TAG NO.	13-LE-0001/0003	13-LE-0002	13-LE-0005/0006
DESCRIPTION	PIG LAUNCHER	PIG RECEIVER	PIG LAUNCHER
DESIGN PRESSURE BARG	FV/369	FV/369	FV/604
DESIGN TEMP. °C	130 (HOLD 1)	130 (HOLD 1)	(HOLD 1)
OPER. PRESSURE BARG	(HOLD 1)	(HOLD 1)	(HOLD 1)
OPER. TEMP. °C	20 TO 110	40	40
SIZE	(HOLD 1)	(HOLD 1)	(HOLD 1)

REVISION	DATE	OWNER	CLASS

PRODUCTION	COMM.	OFFSHORE	ME	HS	PF	HP	HY	QA/QC	JIS	SMOE

REV	DATE	REASON FOR ISSUE	MOD'D	CHK'D	APP'RD
A02	23.01.15	RE-ISSUED FOR COMMENTS	MK	PSA	JoD
A01	20.11.14	ISSUED FOR COMMENTS	SH	NMD	PL
P01	10.11.14	ISSUED FOR IDC	SH	NMD	PL

INTER-DISCIPLINES CHECK

PM	
BD	
HC	
MF	
EF	
PRO	
PI	
HFA	
HFF	
HV	
3D	

JURONG SHIPYARD PTE LTD
(A Subsidiary of SembCorp Marine Ltd)
SINGAPORE

ENGINEERING DEPARTMENT IX SECTION

SFI: 971

TURRET PROCESS FLOW DIAGRAM

PROJECT MANAGER: TMW
SECTION MANAGER: JaD
CHARG. ENGINEER: PSA
CHECKER: KLS
DRAWER: MK
SCALE: N.T.S.
FORMAT: A1

OWNER:	PROJECT: FPSO Pioneiro de Libra
SUB-CON:	JOB NO.: 22-0508
OOGTK DOCUMENT NO.: OOGTKD2-12-L-94-XA-000257-002	OOGTK SFI: 256
SUB-CON DOCUMENT NO.: 8447-LMC-PRO-DWG-6125-002	
CLASS: ABS	TOTAL SHEET: 2
REV: A02	OOGTK DOC STATUS CODE: 2

ITEM	DRAWING No.	DRAWING / DOCUMENT TITLE	REV

REV	DATE	REASON FOR ISSUE	MOD'D	CHK'D	APP'RD

REV	DATE	REASON FOR ISSUE	MOD'D	CHK'D	APP'RD

REV	DATE	REASON FOR ISSUE	MOD'D	CHK'D	APP'RD

REV	DATE	REASON FOR ISSUE	MOD'D	CHK'D	APP'RD

REV	DATE	REASON FOR ISSUE	MOD'D	CHK'D	APP'RD